



NOTES

- 1- ALL DIMENSIONS ARE IN MM
- 2- THE CONTRACTORS SHALL CHECK ALL THE DIMENSIONS PRIOR TO COMMENCEMENT OF CONSTRUCTION AND REPORT ANY DISCREPANCY TO THE CLIENT.
- 3- THE MATERIALS FOR NEW CONSTRUCTION SHALL BE SIMILAR TO THE EXISTING SO THAT THE NEW WORK SHALL BLEND INTO EXISTING.
- 4- EXISTING AND PROPOSED DRAINAGE LAYOUT IS ONLY BASED ON LIMITED SITE INSPECTION. THE CONTRACTOR SHALL INVESTIGATE THIS FURTHER DURING CONSTRUCTION AND PROVIDE ADEQUATE SYSTEM TO CATER FOR ALL FACILITIES AND APPLIANCES.
- 5- THESE DRAWINGS ARE ONLY FOR LOCAL AUTHORITY OR STATUTORY APPROVALS SUCH AS PLANNING PERMISSION, ETC.
- 6- THE CLIENT RESPONSIBLE IN SERVING ALL THE APPROPRIATE PARTY WALL NOTICES UNDER PARTY WALL ACTS.

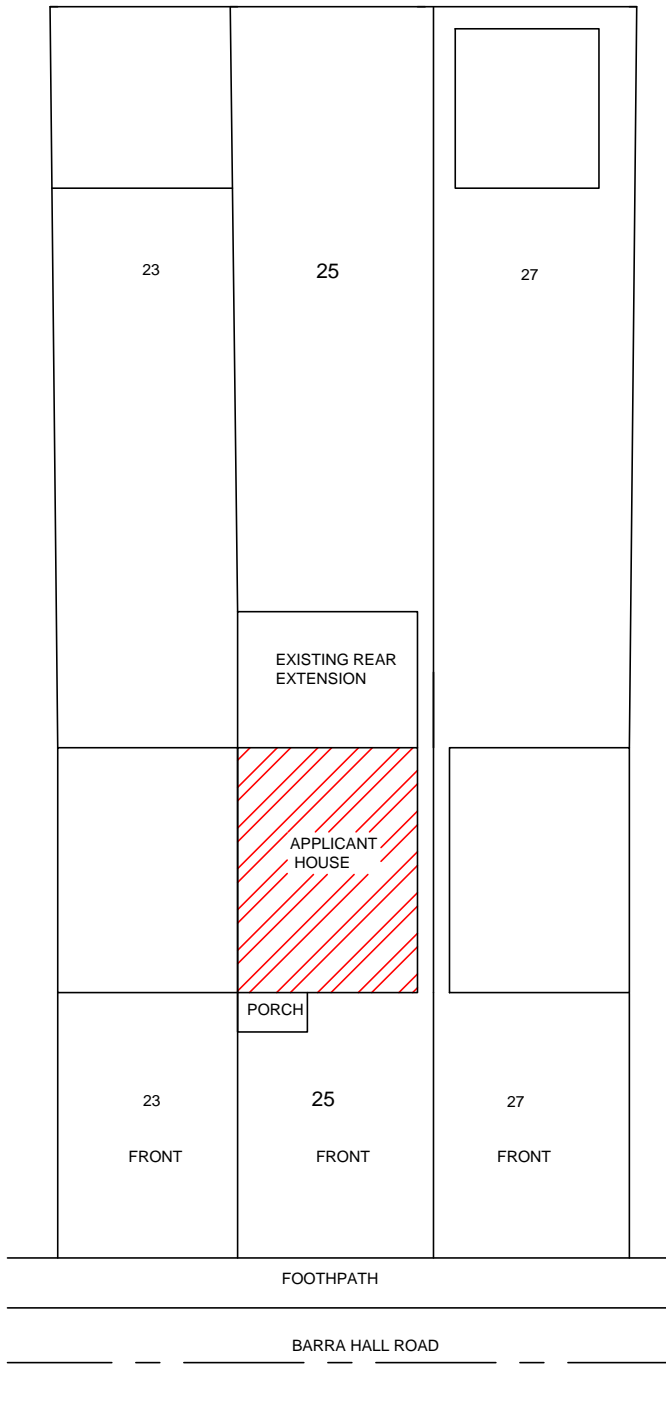

BLOCK PLAN

 SCALE 1:250



SITE ADDRESS		25 BARRA HALL ROAD, HAYES, UB3 2NS	
DRAWING TITLE:		BLOCK PLAN	
SCALE:		1:100 @ A4	DATE 07-01-2026
DRAWING NO:		26/BR25/02	REV