



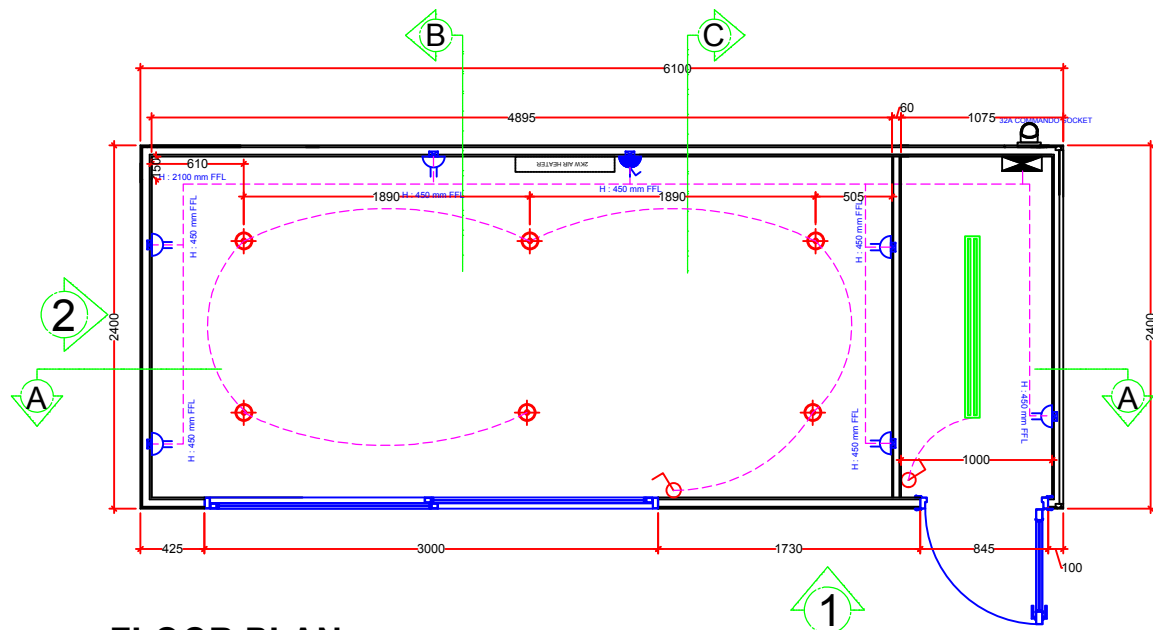


FLOOR PLAN

SCALE : 1: 50@A3

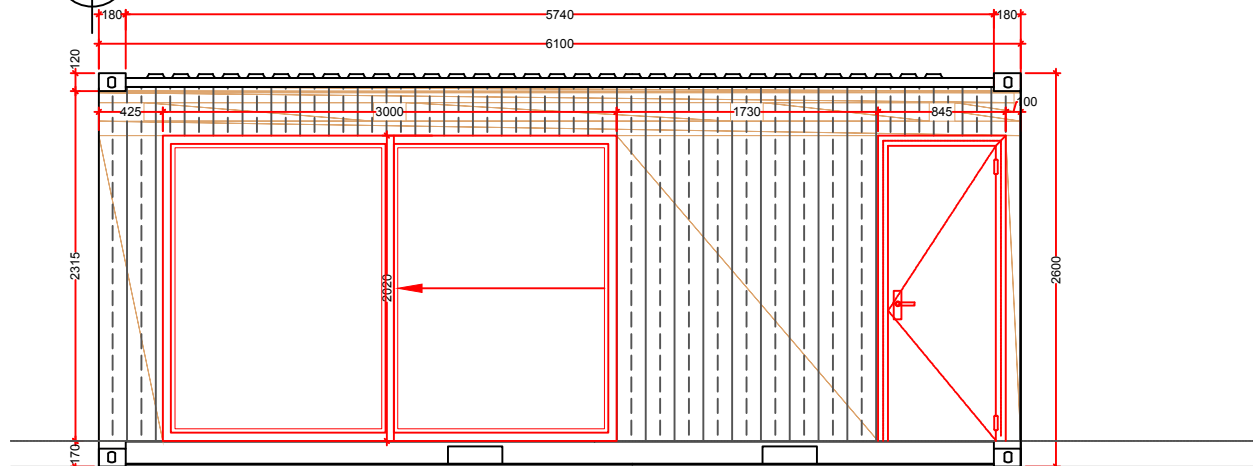


ELEVATION 1

SCALE : 1: 50@A3

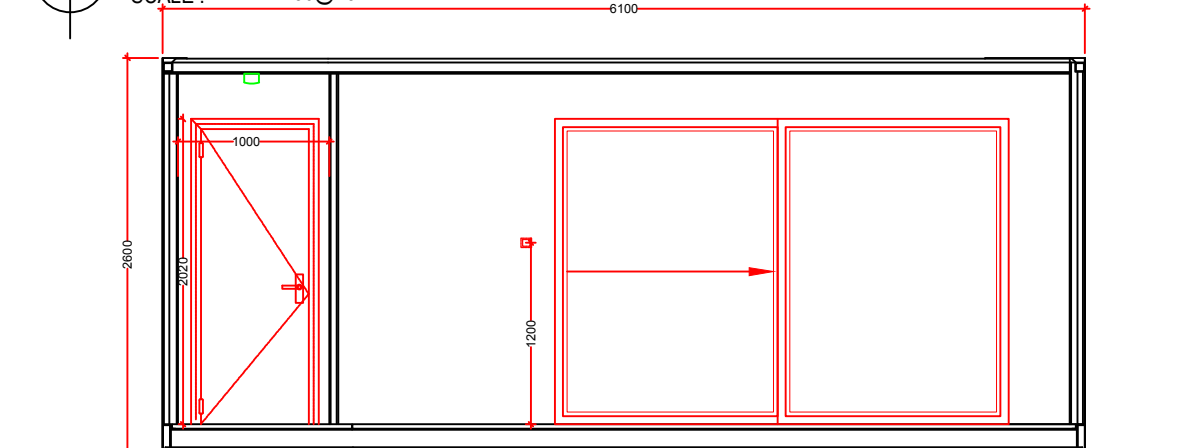


SECTION A-A

SCALE : 1: 50@A3

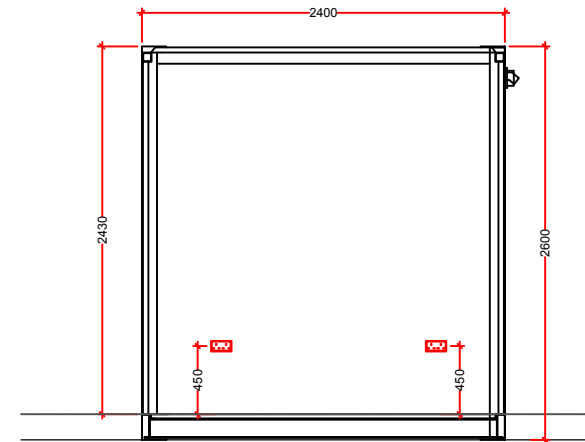


SECTION B-B

SCALE : 1: 50@A3

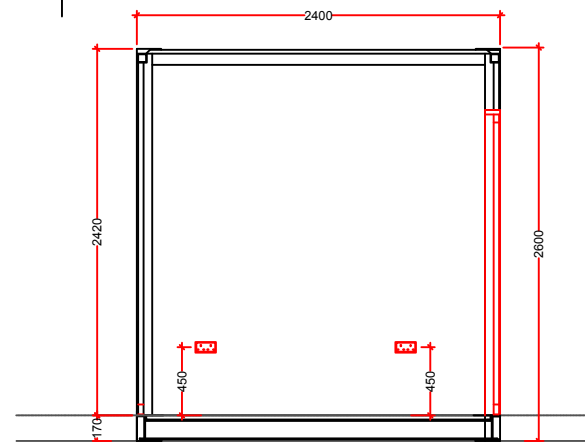

SECTION C-C

 SCALE : 1: 50@A3



LEGEND:	
SYMBOL	DESCRIPTION
	13A 220V 2P+E POWER OUTLET, WALL TYPE @ 450 MM FROM FLOOR LEVEL
	FUSE SWITCH ISOLATOR
	DISTRIBUTION PANEL (CONSUMER UNIT)
	SUSPENDED LIGHT
	SPOT LIGHT
	2KW ELECTRICAL HEATER
	1 GANG LIGHT SWITCH @ 1200 MM FROM FLOOR LEVEL
	CABLE RUN EMBEDDED IN CEILING OR WALL
	32A CONNECTOR POWER IN

IN1	DATE
IN0	DATE
IN	DATE



CONTAINER CONVERSION
DESIGN & BUILD

PROJECT

DRAWING TITLE
PRADEEP SIAN
PLAN AND ELEVATIONS

DRAWINGS

CDB Containers
Twyn Mawr
Farm,
Felindre,
Swansea
SA5 7PL
02920 099 096
hello@containerconversiondb.co.uk
www.containerconversiondb.co.uk

SIGN & DATE	DEPARTMENT
DRAWN	PROJECT NO.
TRACED	SCALE @ 1:100
CHECKED	DRG NO.
APPRD	

APPROVAL OF LAYOUT	
ANY COST OR TIME DELAYS ARISING FROM CHANGES AFTER LAYOUT APPROVAL WILL BE CHARGEABLE TO THE CLIENT.	SIGNED BY:
	POSITION:
	DATE:
WORK WILL NOT COMMENCE ON THIS PROJECT UNTIL A SIGNED DRAWING INDICATING APPROVAL OF LAYOUT IS RECIEVED.	

THIS DRAWING AND ALL COPIES THEREOF ARE CONFIDENTIAL AND THE PROPERTY OF CDB. ANY PART OF THE DRAWING SHALL NOT BE COPIED, REPRODUCED, DISTRIBUTED OR DISCLOSED WITHOUT WRITTEN APPROVAL FROM CDB.