


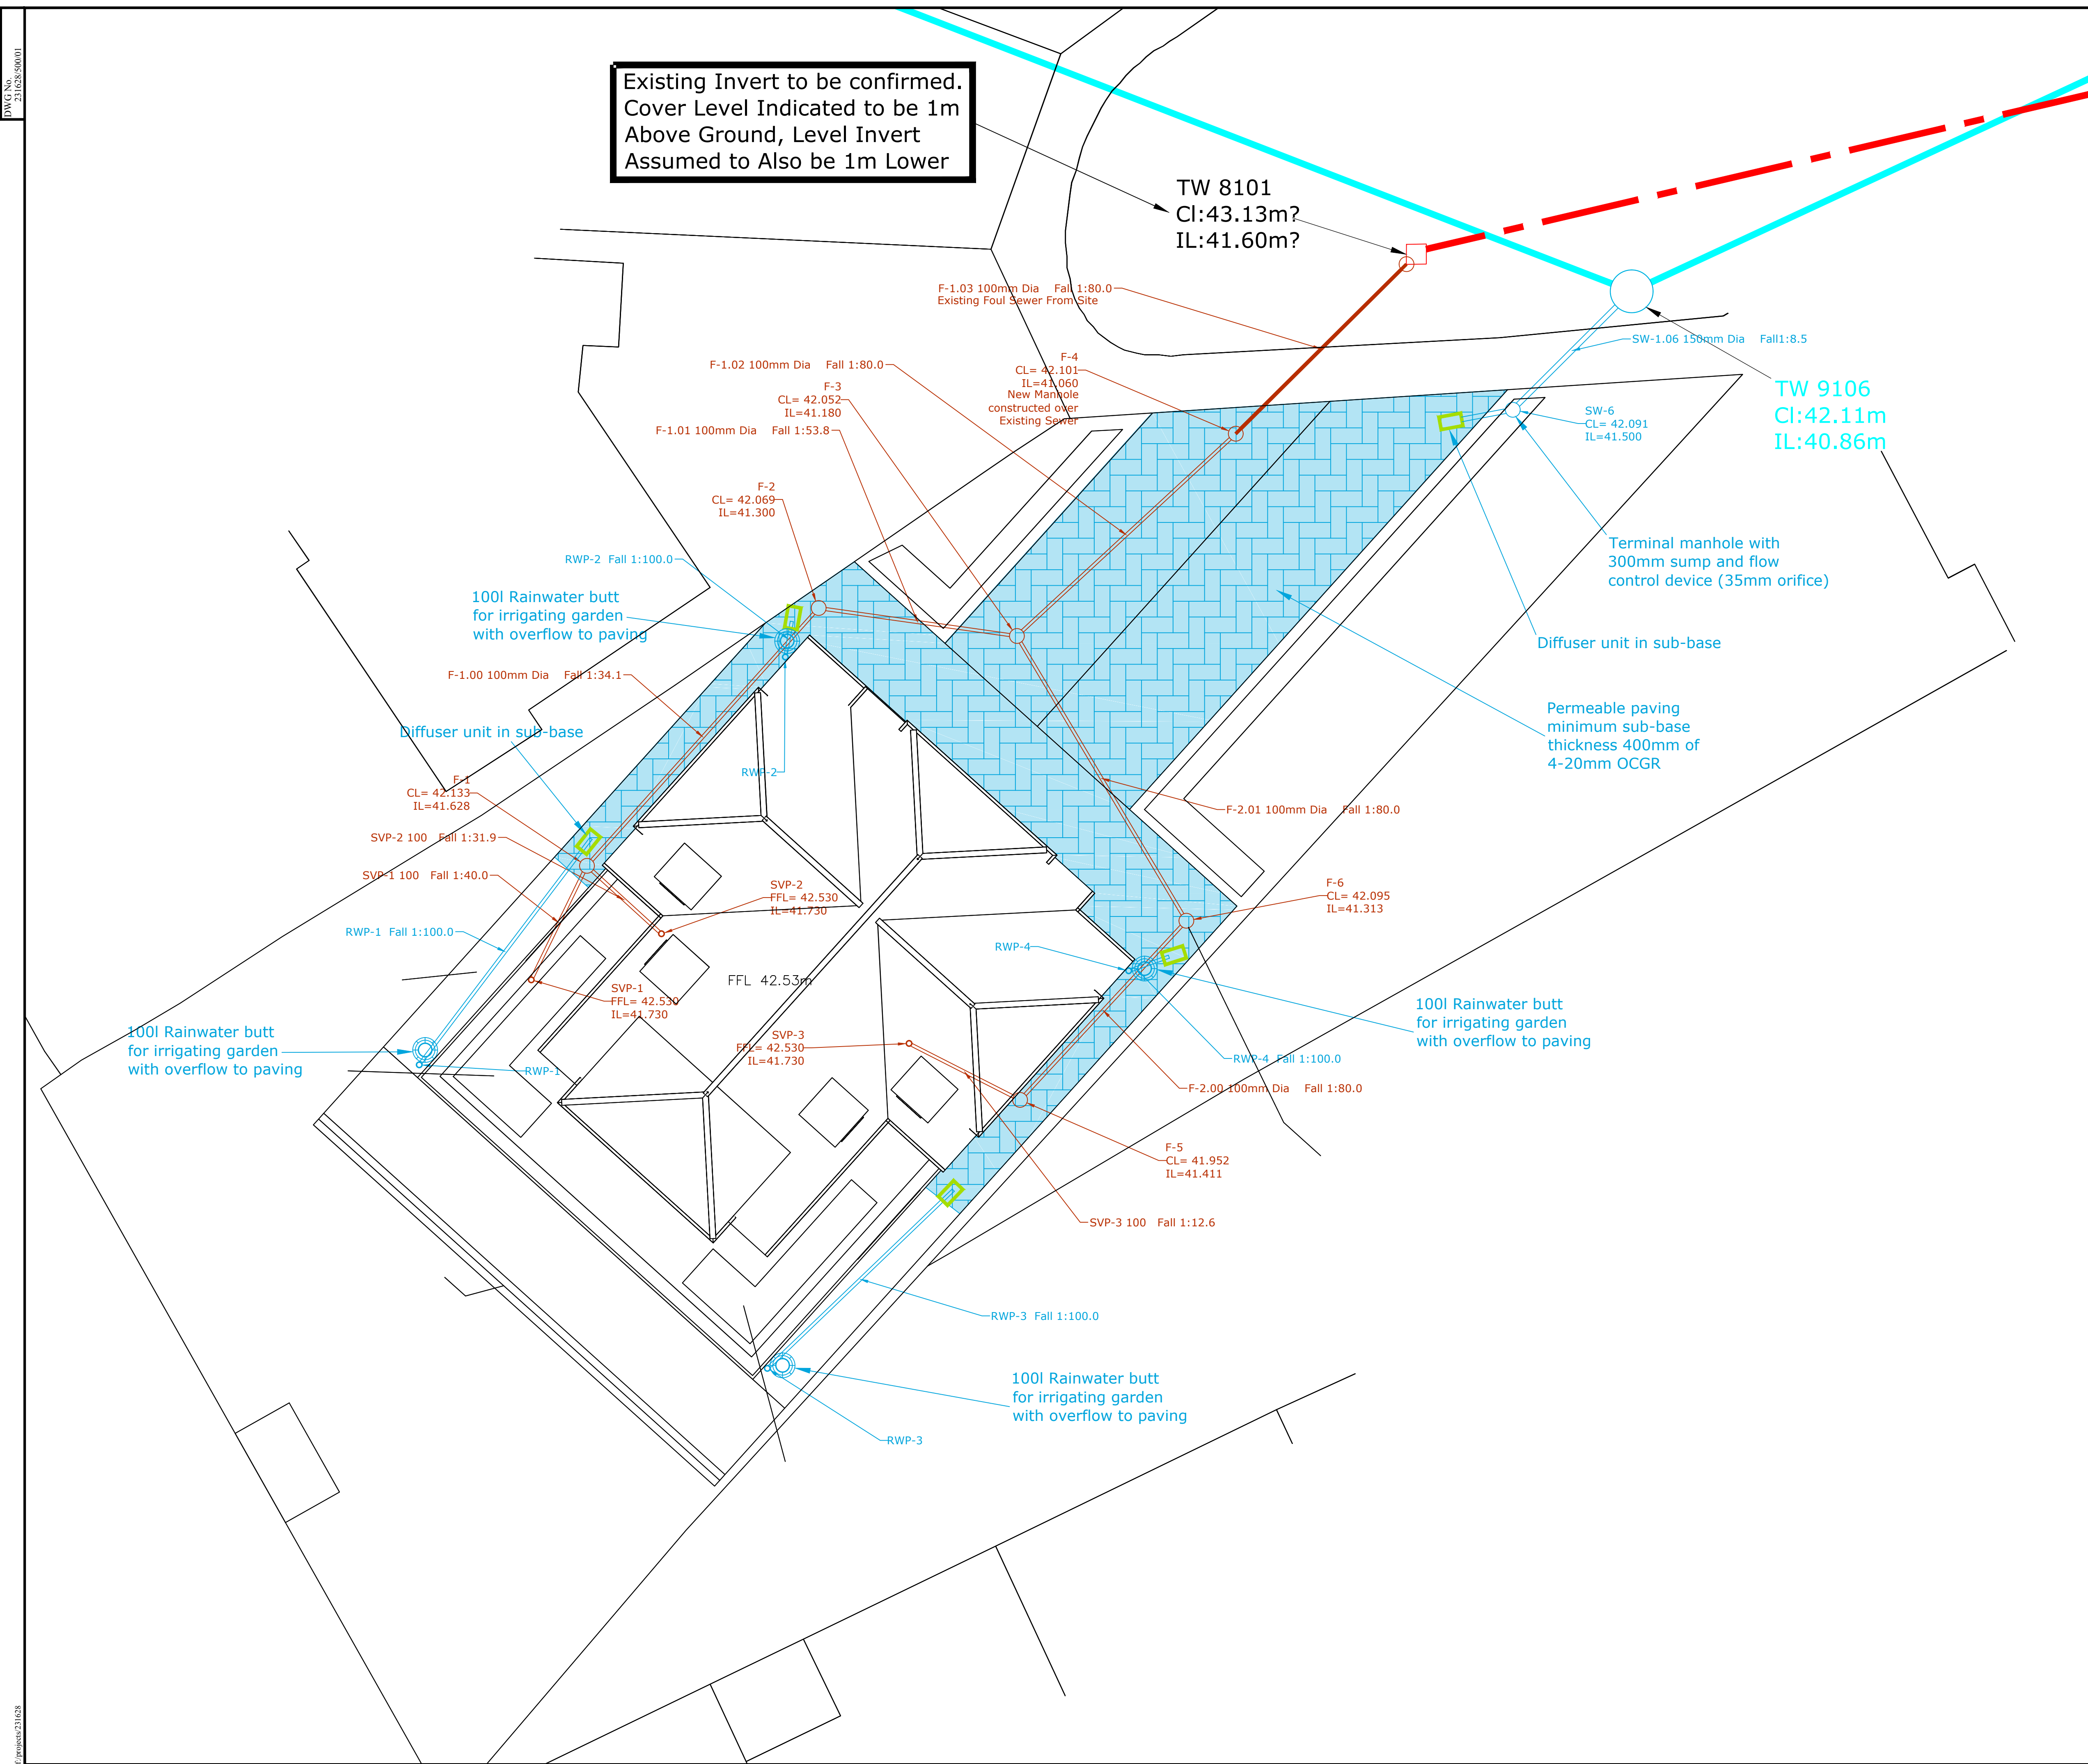

Existing Invert to be confirmed.
Cover Level Indicated to be 1m
Above Ground, Level Invert
Assumed to Also be 1m Lower

TW 8101
Cl:43.13m?
IL:41.60m?

TW 9106
Cl:42.11m
IL:40.86m

Key:

-  Adopted Foul Sewer
 Adopted Surface Water Sewer
 Proposed Foul Drainage
 Proposed Surface Water Drainage
 Proposed Storage Tank
 Proposed Gully

NOTES

C	Rainwater Butts Added	RS	KBL	KBL	11/7/23
B	Foul drainage amended	RS	KBL	KBL	1/6/23
A	SW drainage amended to permeable paving	RS	KBL	KBL	23/5/23
Rev	Amendment	Drawn	Checked	Approved	Date

 **LANMOR Consulting**

Civil Engineers & Transport Planning

Thorogood House, 34 Tolworth Close, Surbiton, Surrey, KT6 7EW
Telephone: 0208 339 7899 Fax: 0208 339 7898
e-mail: info@lanmor.co.uk
www.lanmor.co.uk

7 Weadow Close

Proposed Drainage Layout

DRAWN RS		CHECKED KBL		APPROVED KBL	
DATE Apr 23		DATE Apr 23		DATE Apr 23	
SCALE 1 : 100		PRJ No. 231628		SIZE	REV
DWG No. 231628/500/01				A1	C