

DWG No. 231628/500/01

* TREE HEIGHT
57.768

* TREE HEIGHT
55.691

U:\projects\231628

Existing Invert to be confirmed.
Cover Level Indicated to be 1m
Above Ground, Level Invert
Assumed to Also be 1m Lower


TW 8101
Cl:43.13m?
IL:41.60m?

TW 9106
Cl:42.11m
IL:40.86m

NOTES

Key:

- Adotped Foul Sewer
- Adopted Surface Water Sewer
- Proposed Foul Drainage
- Proposed Surface Water Drainage
- Proposed Storage Tank
- Proposed Gully

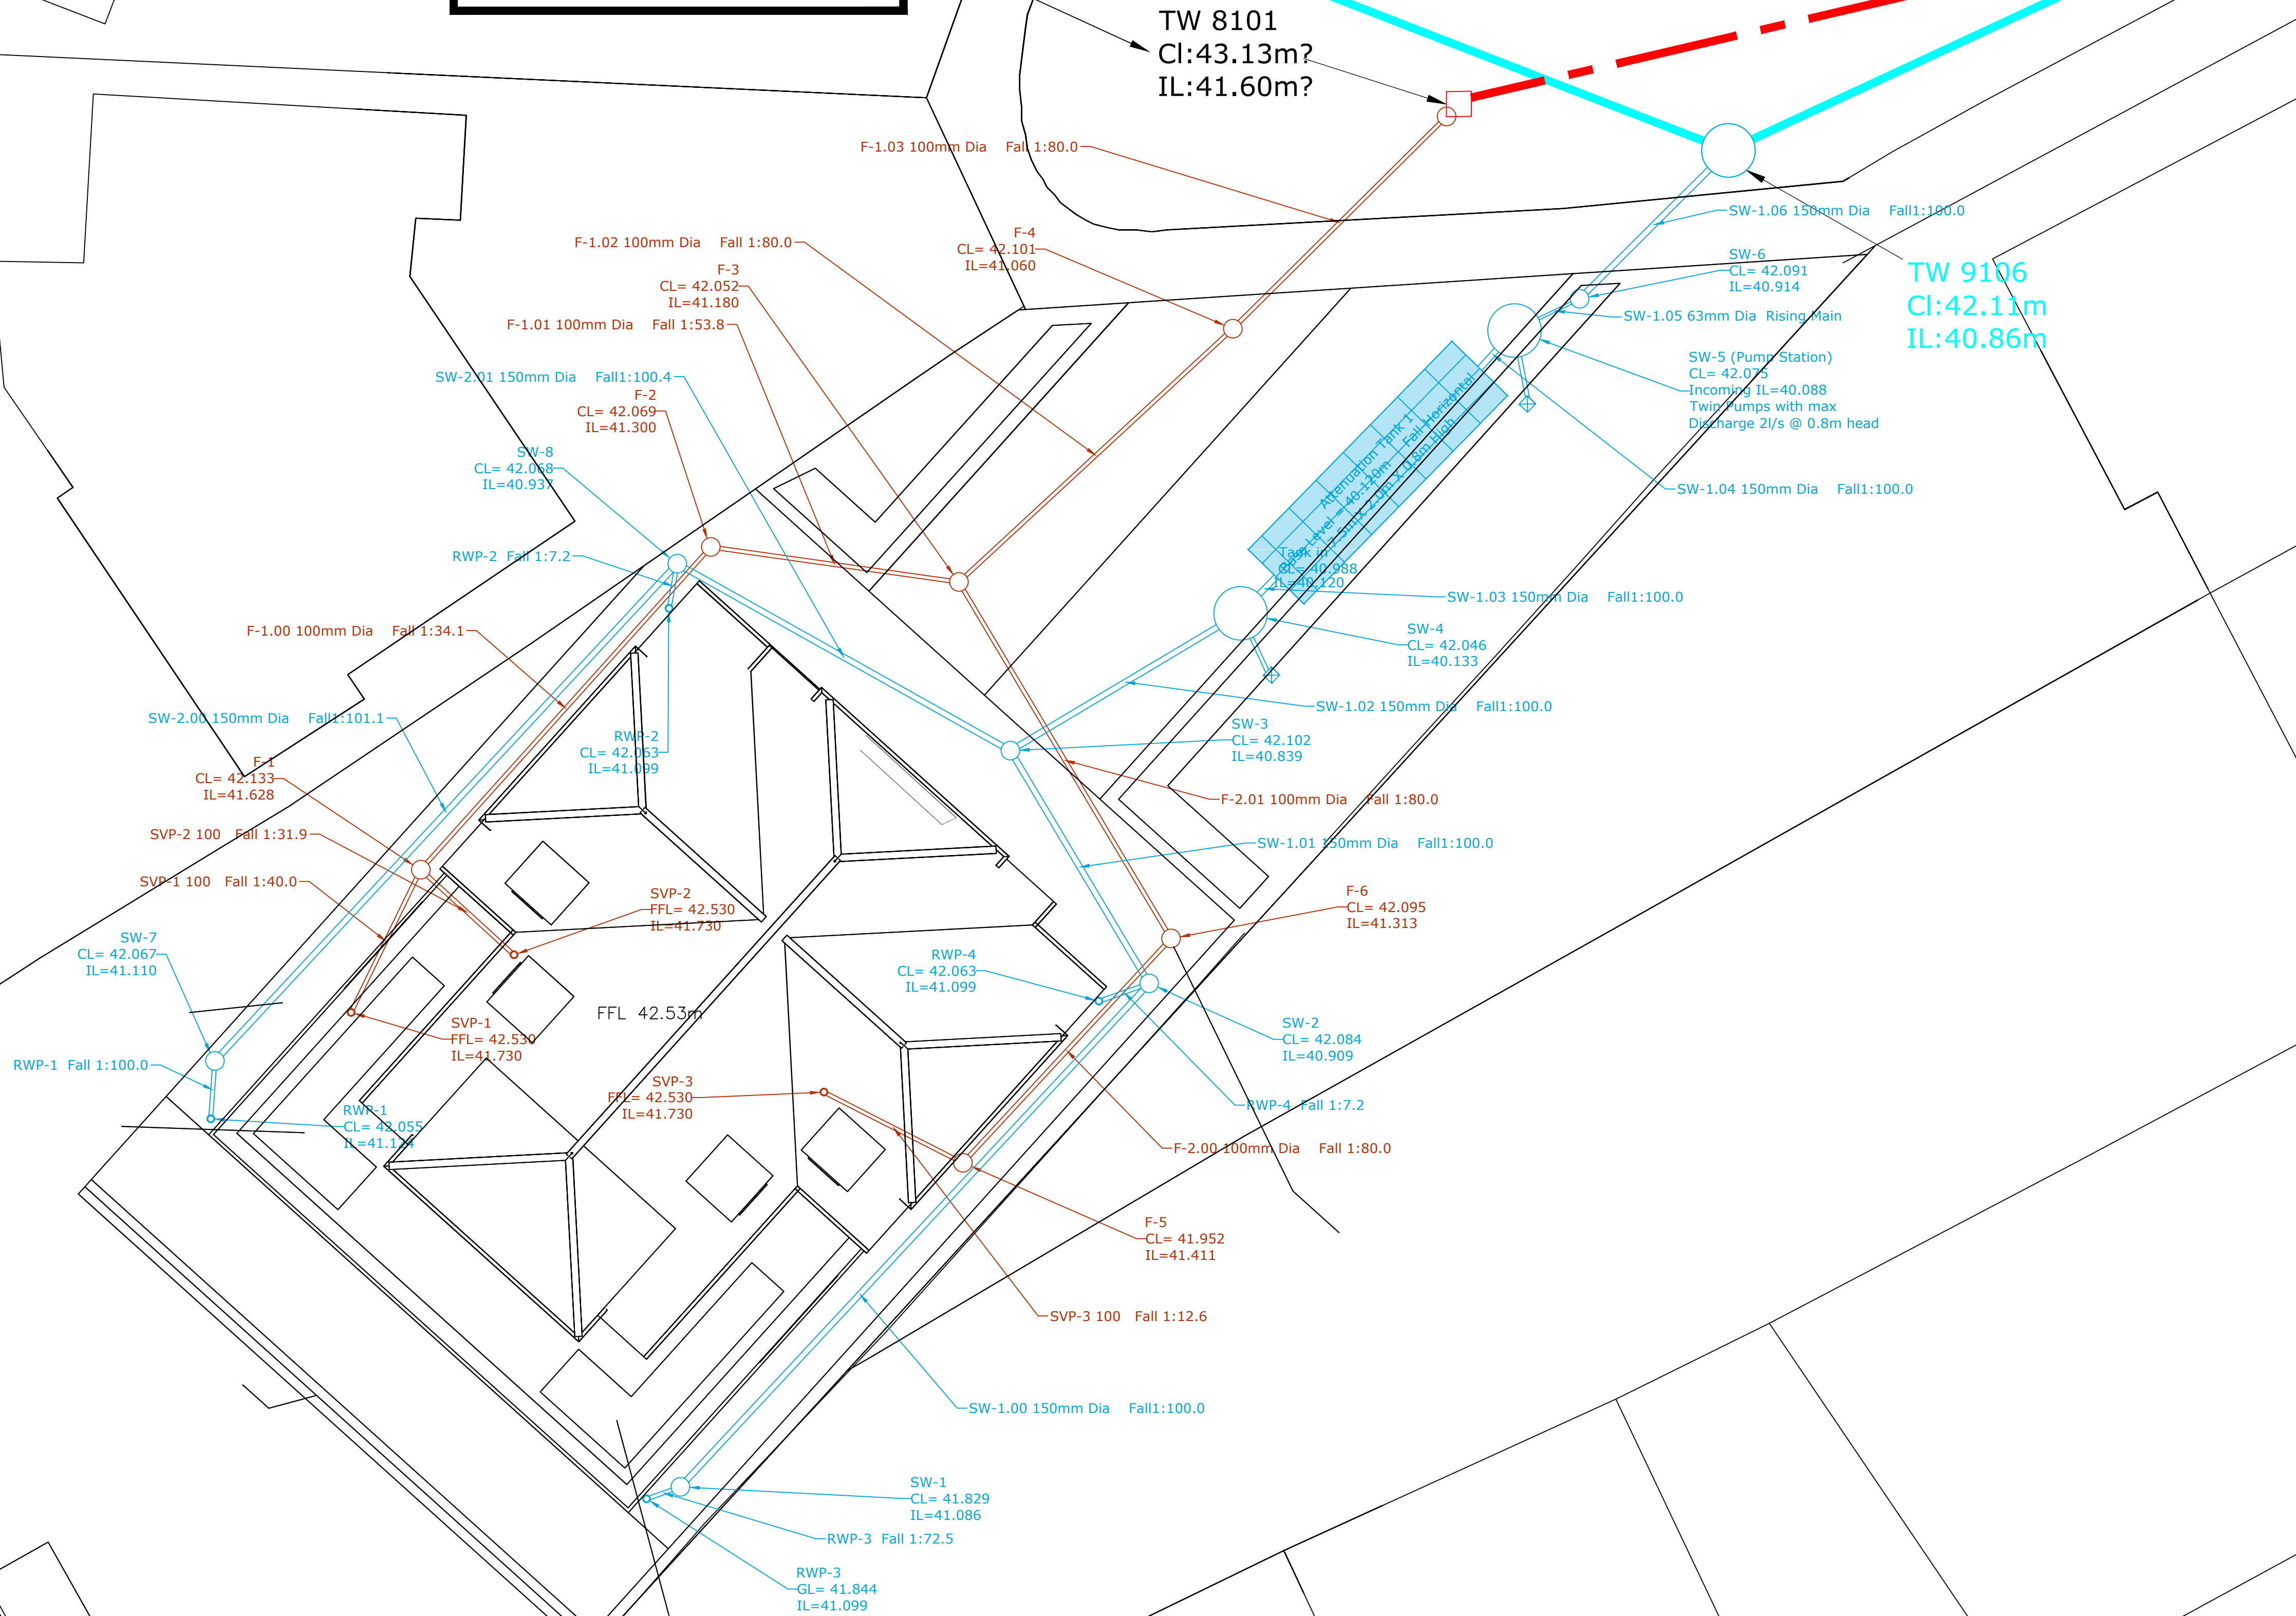

Rev	Amendment	Drawn	Checked	Approved	Date

LANMOR Consulting

Civil Engineers & Transport Planning

Thorogood House, 34 Tolworth Close, Surbiton, Surrey, KT6 7EW
Telephone: 0208 339 7899 Fax: 0208 339 7898
e-mail: info@lanmor.co.uk
www.lanmor.co.uk

7 Weadow Close					
Proposed Drainage Layout					
DRAWN	RS	CHECKED	KBL	APPROVED	KBL
DATE	Apr 23	DATE	Apr 23	DATE	Apr 23
SCALE	1 : 100	PRJ No.	231628	SIZE	REV
DWG No.	231628/500/01			A1	