 


GENERAL NOTES

1. THE CONTRACTOR MUST CHECK ALL DIMENSIONS ON SITE BEFORE COMMENCING WORK
2. ANY DISCREPANCIES MUST BE IMMEDIATELY BROUGHT TO THE ATTENTION OF THE DESIGNER
3. ALL WORK MUST CONFORM TO CURRENT BUILDING REGULATIONS, BRITISH STANDARDS & CODES OF PRACTICE AND NHBC STANDARDS
4. THESE DRAWINGS ARE TO BE READ IN CONJUNCTION WITH ALL RELEVANT DESIGNER, ENGINEER OR SPECIALIST DRAWINGS AND SPECIFICATIONS
5. ALL DIMENSIONS ARE IN MILLIMETERS UNLESS STATED OTHERWISE
6. ALL MATERIALS ARE TO BE USED AND INSTALLED IN STRICT COMPLIANCE WITH THE RELEVANT MANUFACTURER'S RECOMMENDATIONS
7. THE CONTRACTOR IS RESPONSIBLE FOR PROVIDING ALL NECESSARY TEMPORARY SUPPORT TO THE BUILDING AND ANY ADJACENT STRUCTURES
8. ALL CONSTRUCTION MUST BE BUILT WITHIN THE ACTUAL PROPERTY BOUNDARIES UNLESS PARTY WALL AGREEMENT ALLOWS OTHERWISE

HATCH/LINE LEGEND		DRAINAGE ABBREVIATIONS	
	concrete		demolish
	brickwork		above/beyond
	blockwork		boundary
			drain
			insulation/ stud partition
			mh = manhole
			ic = inspection chamber
			re = rodding eye
			g = gully
			svp = soil vent pipe
			rwp = rain water pipe
			ss = stub stack
			rainwater drainage to contractor design electrical layout to client design

I	insulation changes	16/06/22
H	boundary treatment & embankment changes	08/06/22
G	boundary treatment changes	23/05/22
F	sliding door changes	08/03/22
E	landscaping changes	15/02/22
D	landscaping changes	02/02/22
C	landscaping changes	17/01/22
B	fenestration changes	02/12/21
A	walls adjusted per SE design	02/07/21

REVISION	DESCRIPTION	DATE
----------	-------------	------


DRAW AND PLAN

T: 0800 689 0101
E: info@drawandplan.com
W: www.drawandplan.com


Location
**29 THE DRIVE
NORTHWOOD
HA6 1HW**

Drawing title
GENERAL ARRANGEMENT


Date		Scale	
08/06/2022		1:50@A1	
Job no.	Dwg no.	Revision	
19102	PGA001	H	
1:50			
1:100			
1:200			
1:500			

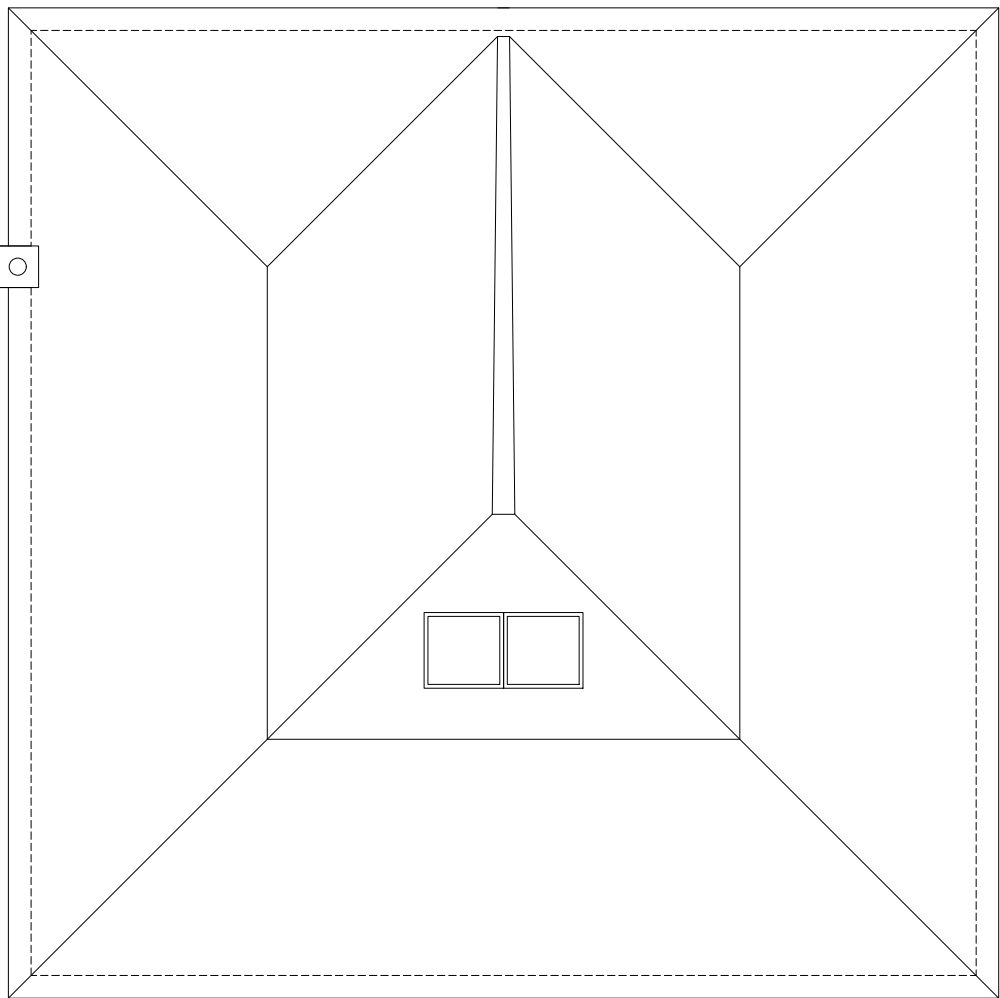

PROPOSED ROOF PLAN
1:100

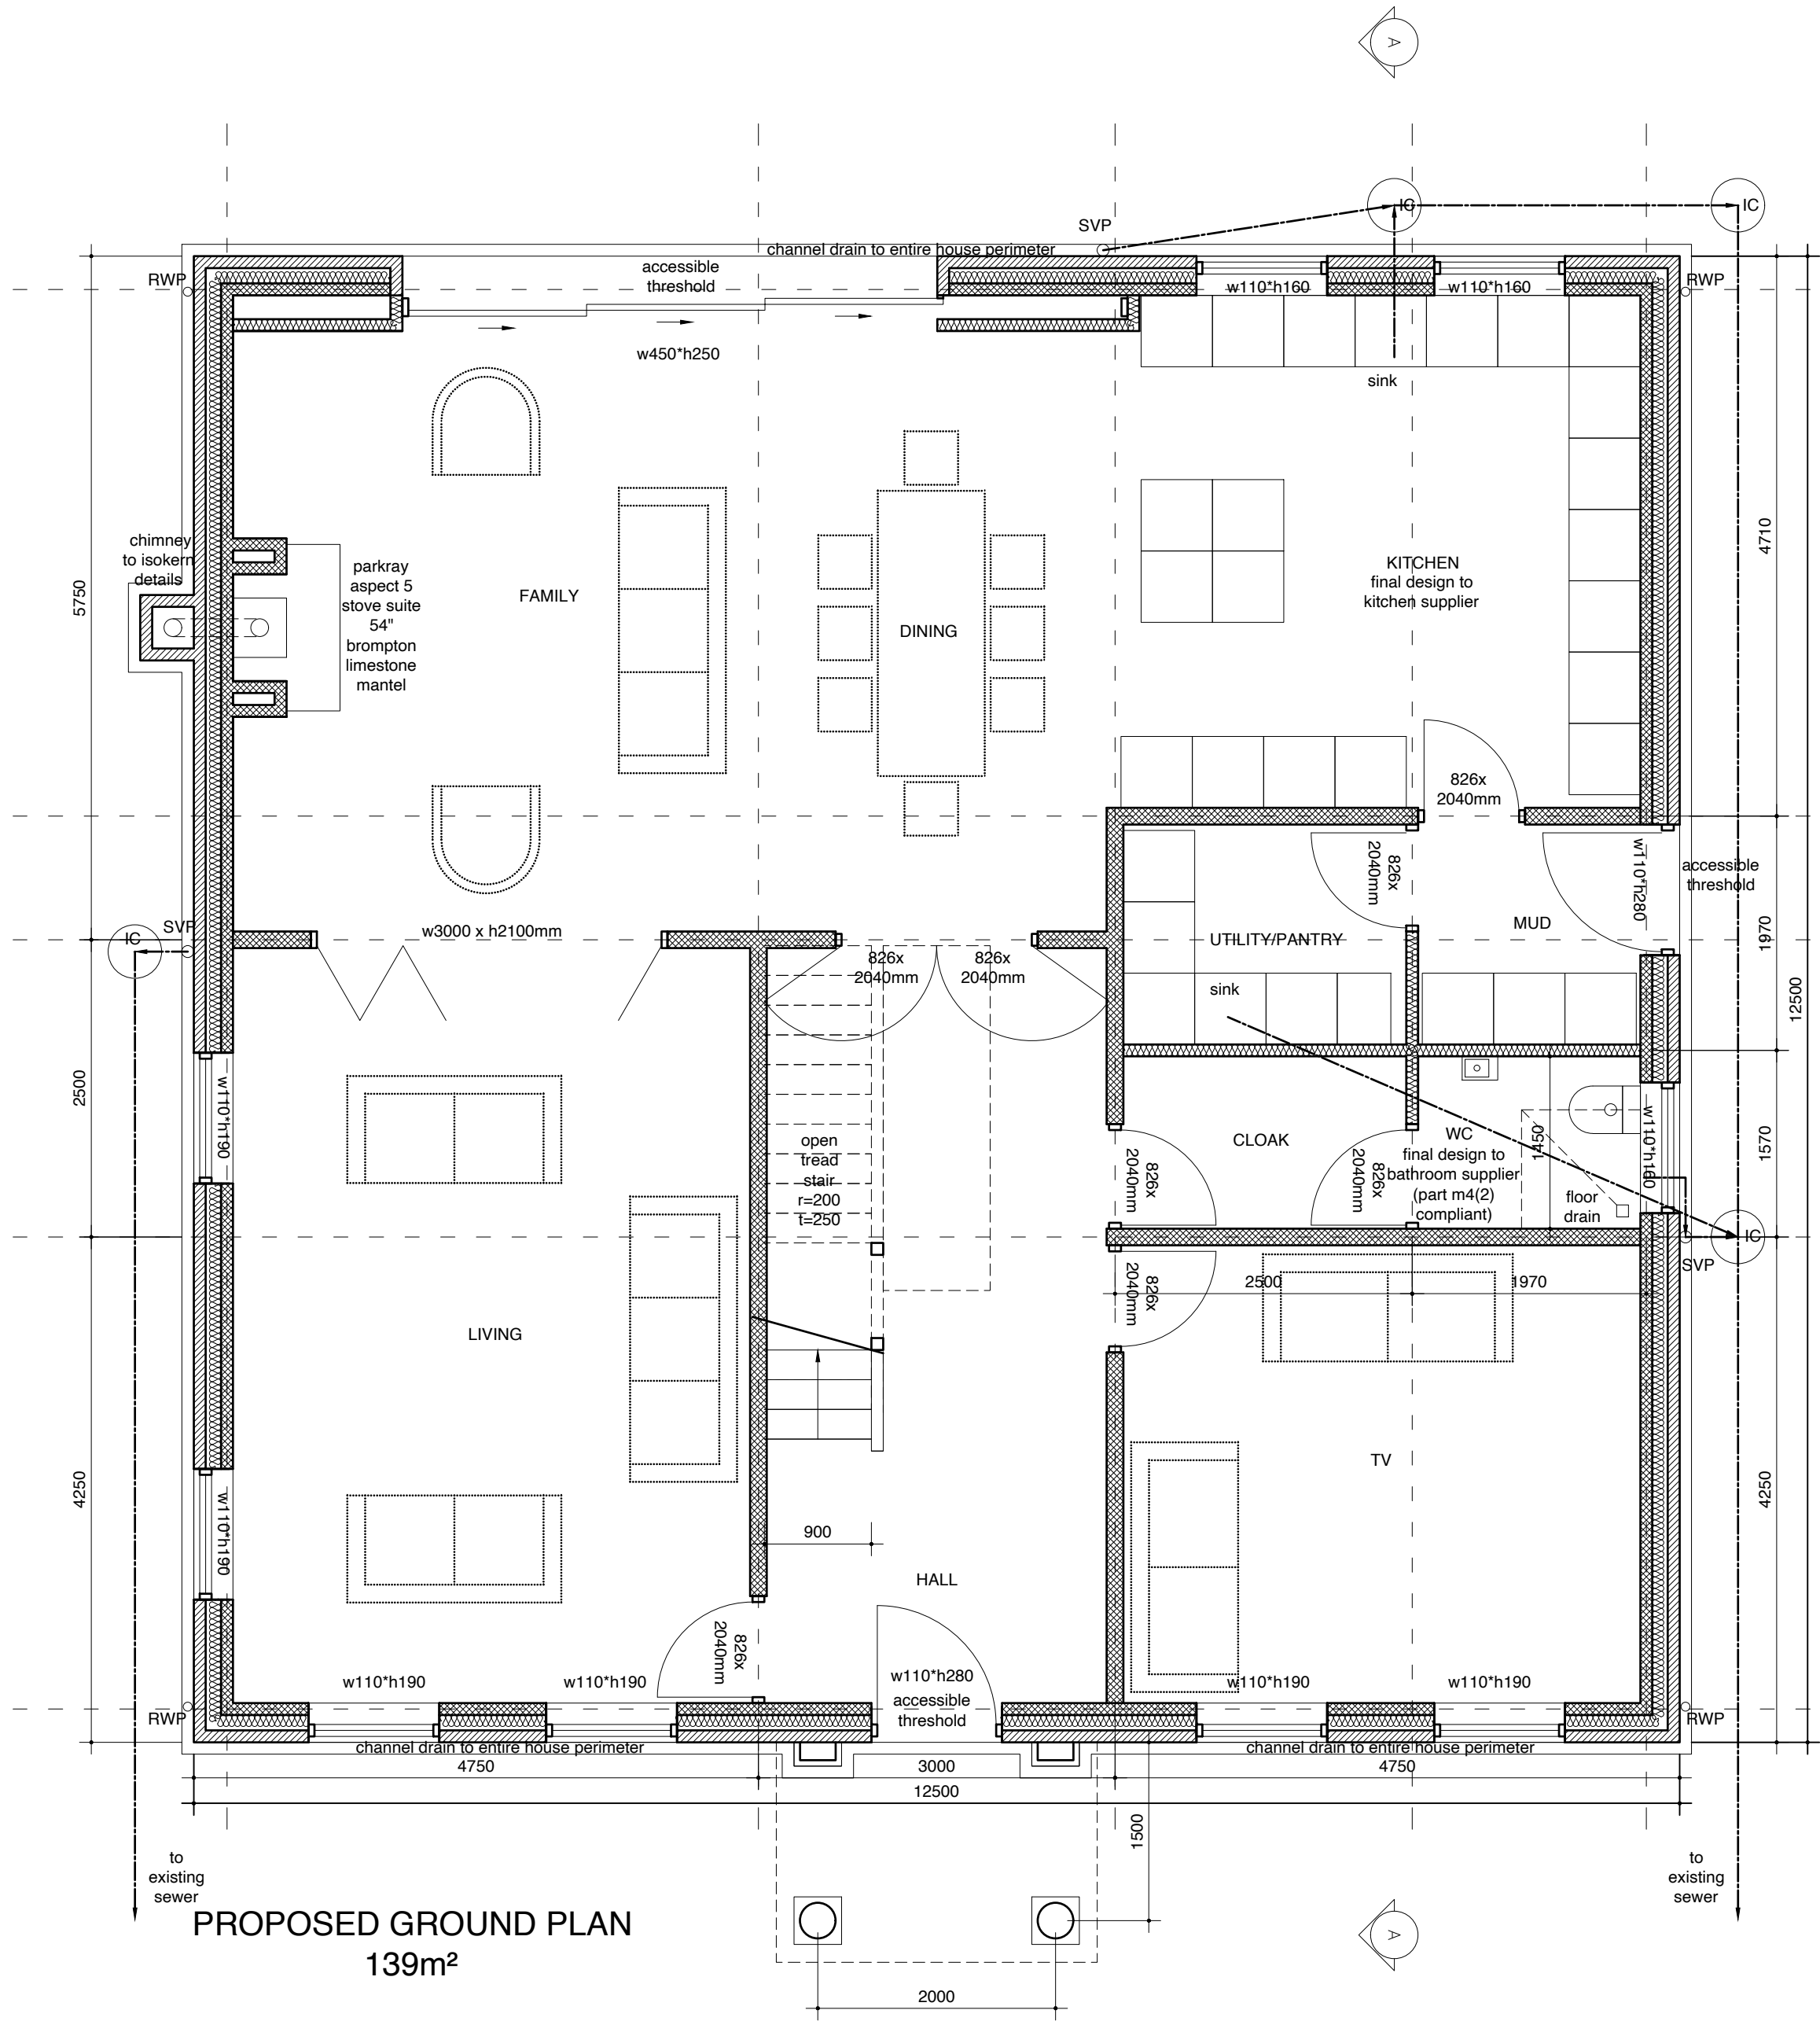

PROPOSED GROUND PLAN
139m²

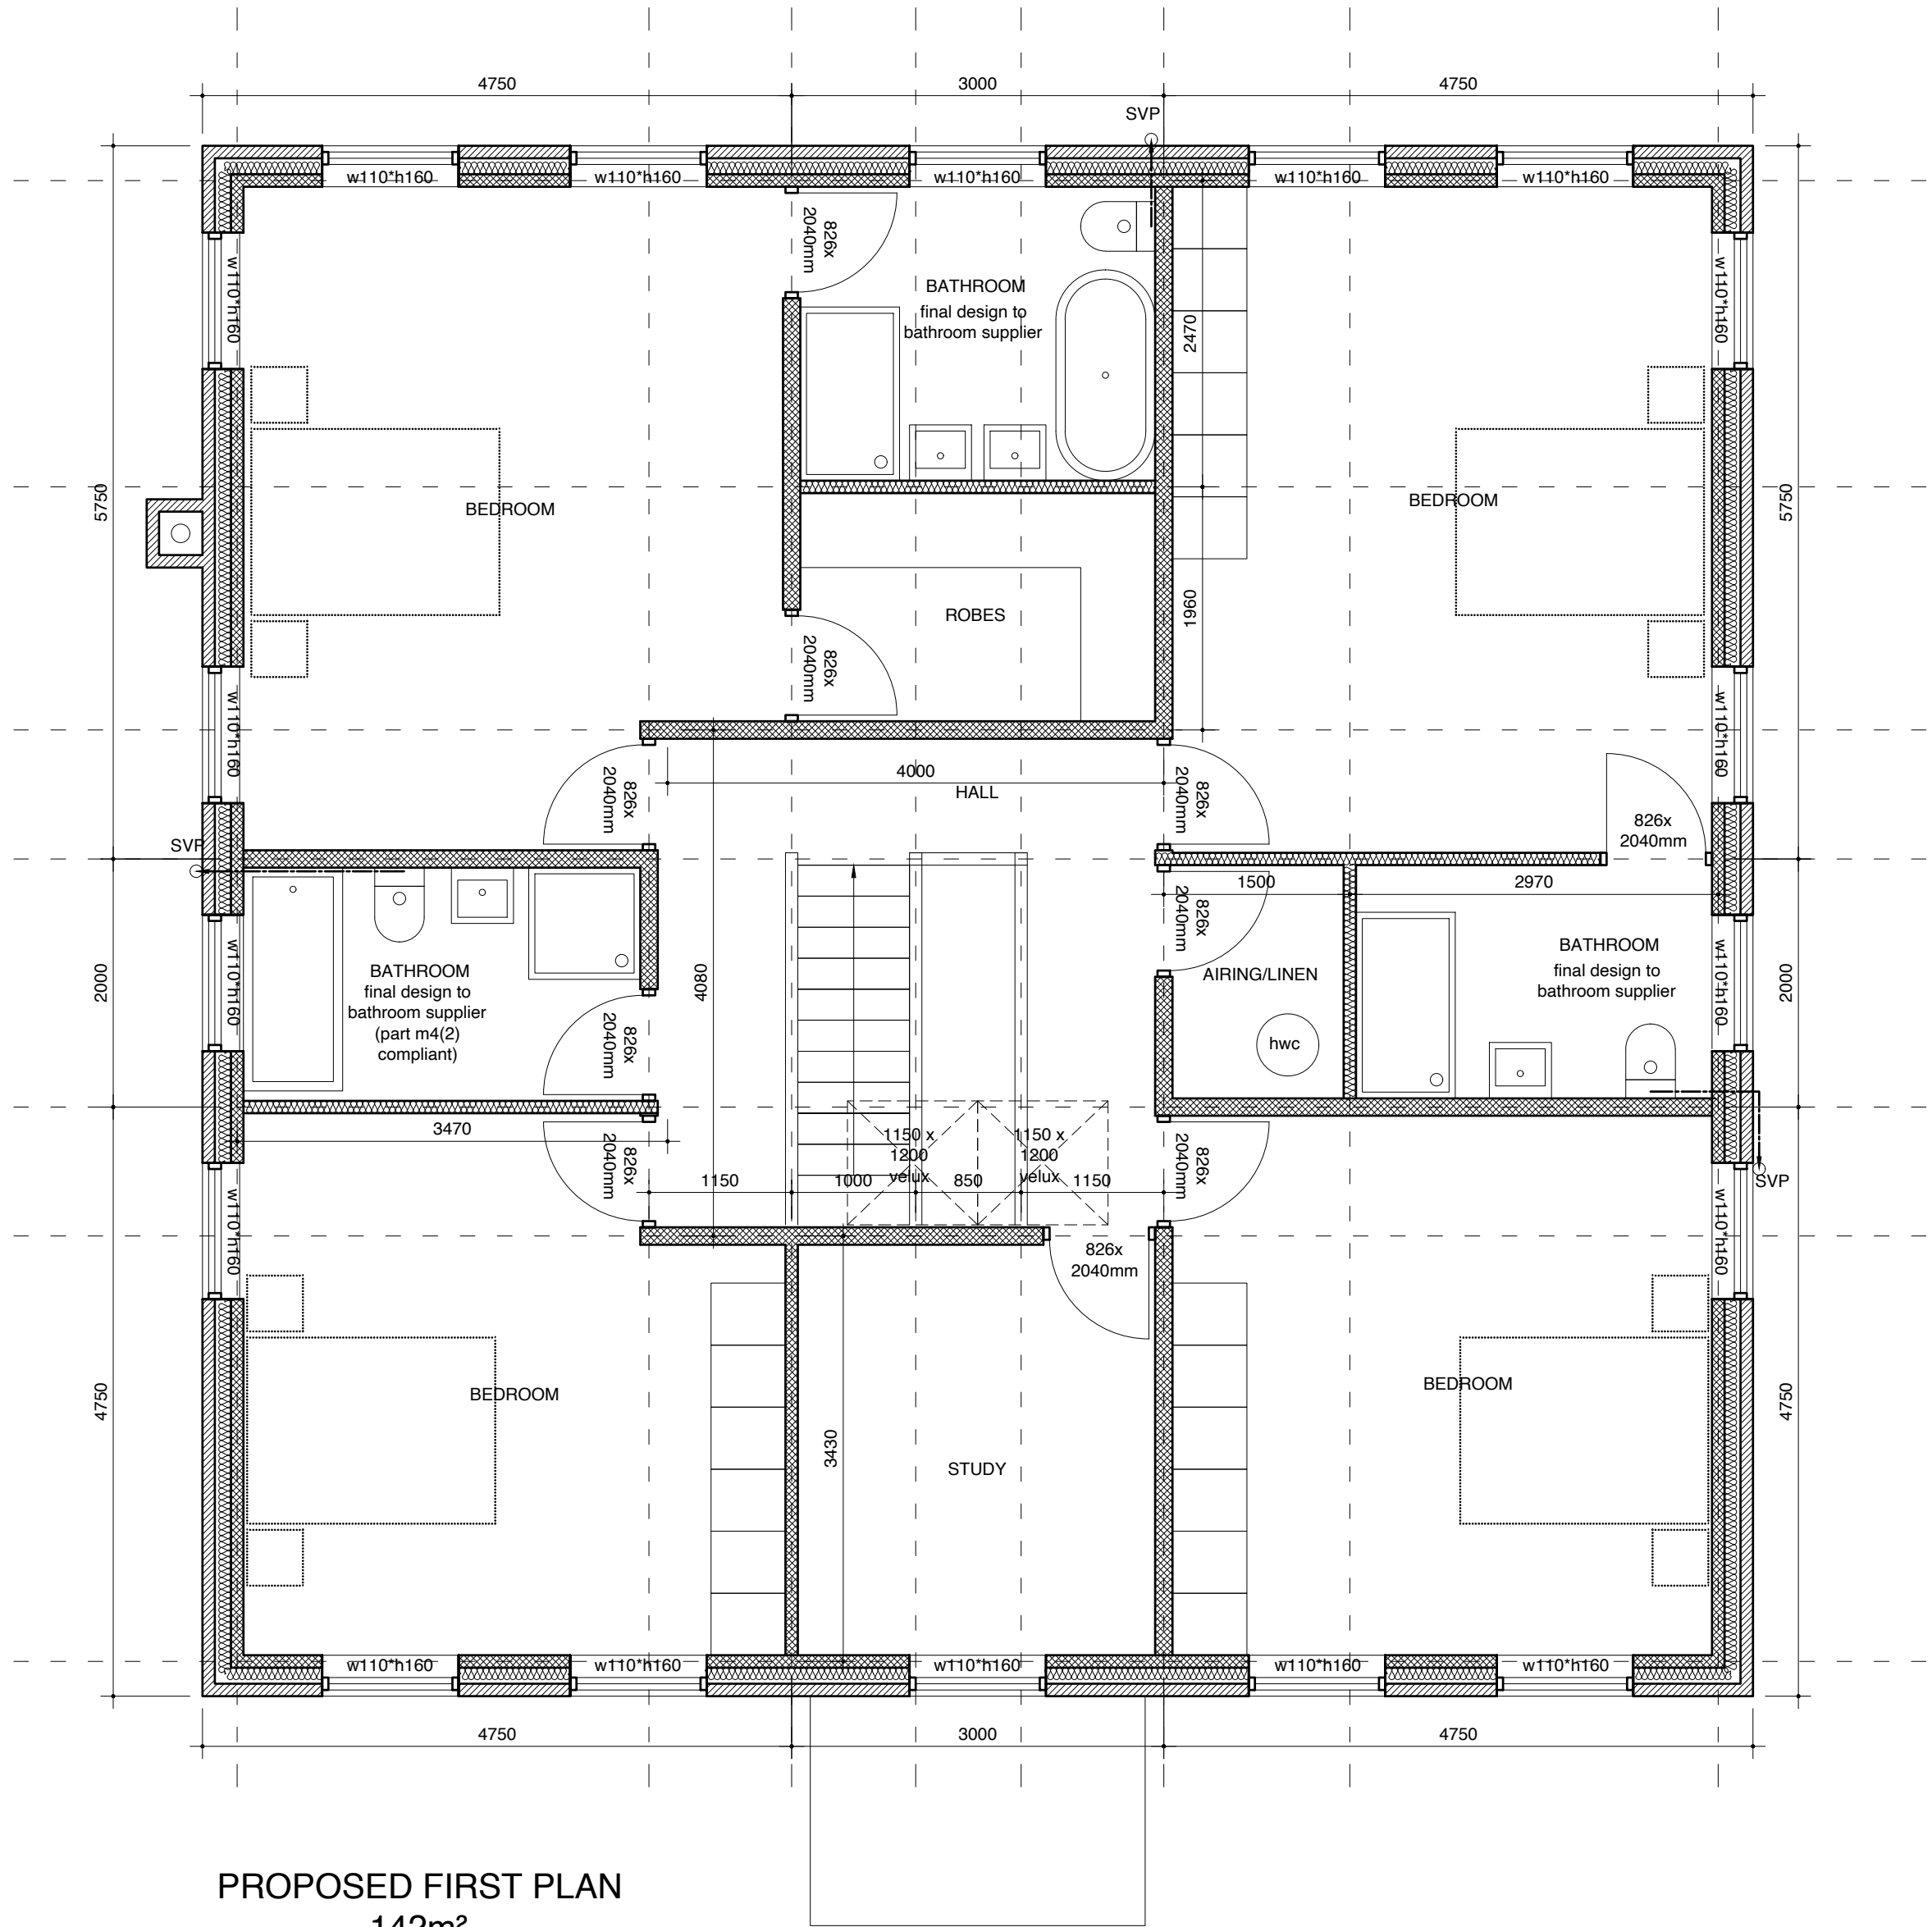

PROPOSED FIRST PLAN
142m²