



GENERAL NOTES

1. THE CONTRACTOR MUST CHECK ALL DIMENSIONS ON SITE BEFORE COMMENCING WORK
2. ANY DISCREPANCIES MUST BE IMMEDIATELY BROUGHT TO THE ATTENTION OF THE DESIGNER
3. ALL WORK MUST CONFORM TO CURRENT BUILDING REGULATIONS, BRITISH STANDARDS & CODES OF PRACTICE AND NHBC STANDARDS
4. THESE DRAWINGS ARE TO BE READ IN CONJUNCTION WITH ALL RELEVANT DESIGNER, ENGINEER OR SPECIALIST DRAWINGS AND SPECIFICATIONS
5. ALL DIMENSIONS ARE IN MILLIMETERS UNLESS STATED OTHERWISE
6. ALL MATERIALS ARE TO BE USED AND INSTALLED IN STRICT COMPLIANCE WITH THE RELEVANT MANUFACTURER'S RECOMMENDATIONS
7. THE CONTRACTOR IS RESPONSIBLE FOR PROVIDING ALL NECESSARY TEMPORARY SUPPORT TO THE BUILDING AND ANY ADJACENT STRUCTURES
8. ALL CONSTRUCTION MUST BE BUILT WITHIN THE ACTUAL PROPERTY BOUNDARIES UNLESS PARTY WALL AGREEMENT ALLOWS OTHERWISE

| HATCH/LINE LEGEND |              | DRAINAGE ABBREVIATIONS                  |
|-------------------|--------------|-----------------------------------------|
|                   | concrete     | mh = manhole                            |
|                   | demolish     | ic = inspection chamber                 |
|                   | above/beyond | re = rodding eye                        |
|                   | brickwork    | g = gully                               |
|                   | blockwork    | svp = soil vent pipe                    |
|                   |              | rwp = rain water pipe                   |
|                   |              | ss = stub stack                         |
|                   |              | rainwater drainage to contractor design |
|                   |              | electrical layout to client design      |

| REVISION | DESCRIPTION                             | DATE     |
|----------|-----------------------------------------|----------|
| I        | insulation changes                      | 16/06/22 |
| H        | boundary treatment & embankment changes | 08/06/22 |
| G        | boundary treatment changes              | 23/05/22 |
| F        | sliding door changes                    | 08/03/22 |
| E        | landscaping changes                     | 15/02/22 |
| D        | landscaping changes                     | 02/02/22 |
| C        | landscaping changes                     | 17/01/22 |
| B        | fenestration changes                    | 02/12/21 |
| A        | walls adjusted per SE design            | 02/07/21 |

DRAW AND PLAN

T: 0800 689 0101  
E: info@drawandplan.com  
W: www.drawandplan.com

Location

29 THE DRIVE  
NORTHWOOD  
HA6 1HW

Drawing title

GENERAL ARRANGEMENT

Date

05/08/2022

Scale

1:50@A1

Job no.



19102

Dwg no.


EGA003

Revision

J

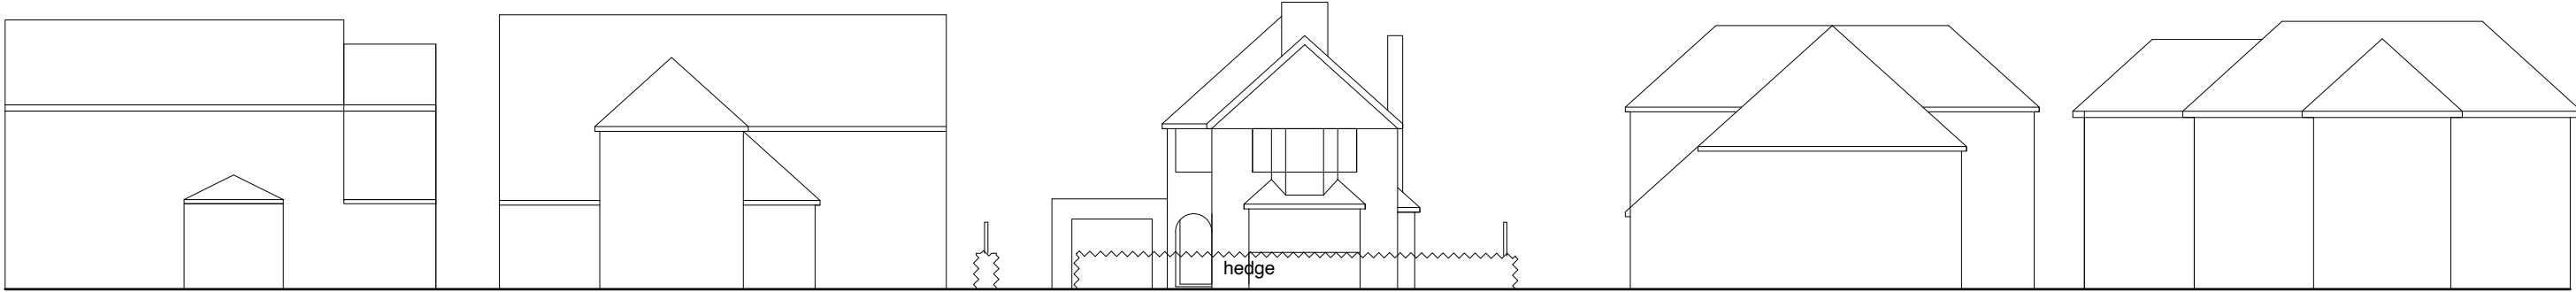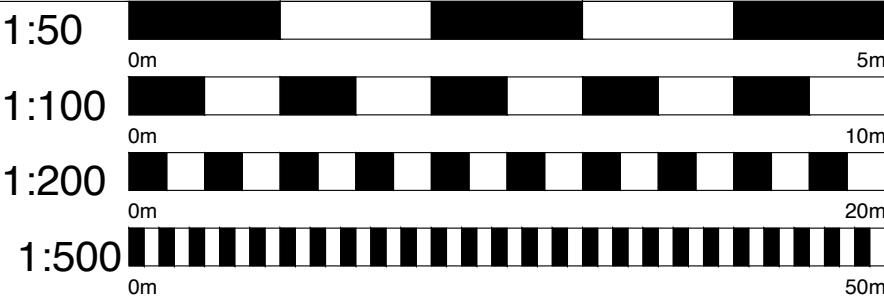


EXISTING STREET ELEVATION 1:200

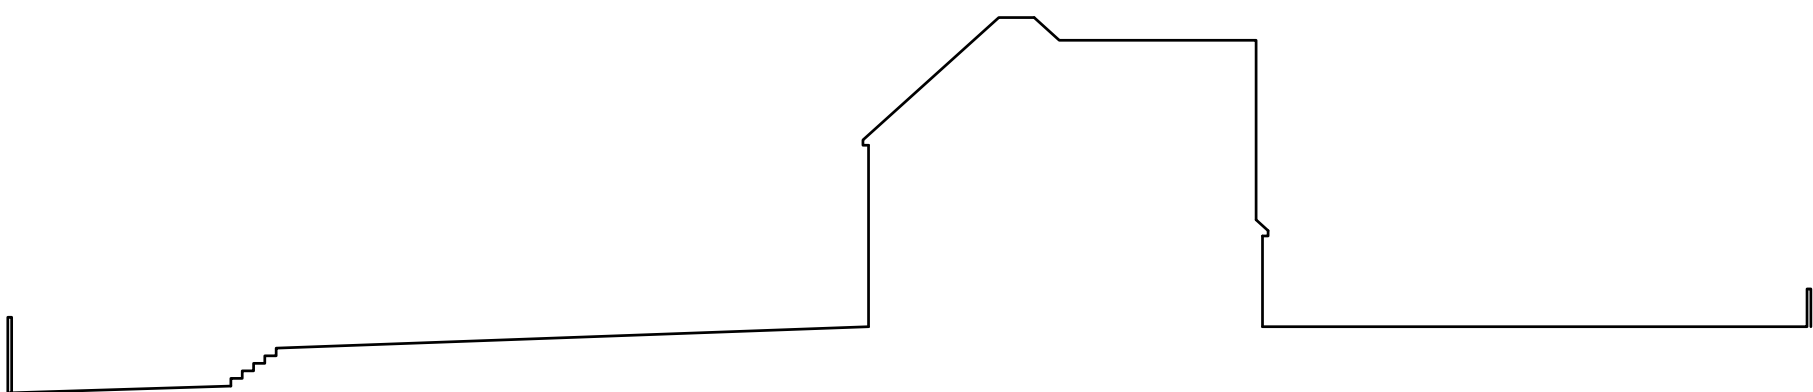


EXISTING SITE SECTION 1:200



 EXISTING SITE FLANK ELEVATION 1:200



EXISTING SITE REAR ELEVATION 1:200

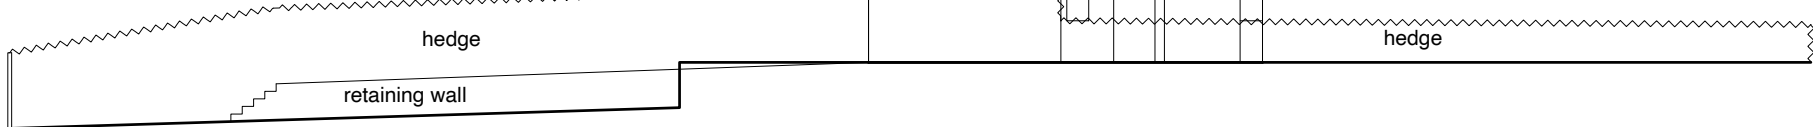

EXISTING SITE FLANK ELEVATION 1:200