



NOTE:
EXISTING BT & TX TO BE RELOCATED TO NEW MK5 LAC.
EXISTING SINGLE PHASE 63A POWER SUPPLY WILL BE
UPGRADED TO THREE PHASE 100A SUPPLY WITH IN MK5 LAC

Antenna Aperture ID	Proposed 4G/5G Bearing	Operator: Shared/ EE/H3G
A1	60°	H3G
A2	60°	EE
A3	60°	EE/H3G
A4	60°	EE/H3G
B1	180°	H3G
B2	180°	EE
B3	180°	EE/H3G
B4	180°	EE/H3G
C1	300°	H3G
C2	300°	EE
C3	300°	EE/H3G
C4	300°	EE/H3G

NOTES:
1. ALL DIMENSIONS IN MM UNLESS OTHERWISE NOTED.

100mm

50mm

10mm

PROPOSED PAVING SLABS INSTALLED AT FOOT OF CABINET DOORS ON GRASS AREA FOR HEALTH AND SAFETY OF WORKERS ON SITE

PROPOSED 1No. MK5 LINK AC CABINET TO BE INSTALLED ON PROPOSED ROOT FOUNDATION

PROPOSED 1No. POGONA CABINET TO BE INSTALLED ON PROPOSED ROOT FOUNDATION

PROPOSED 1No. BOWLER CABINET TO BE INSTALLED ON PROPOSED ROOT FOUNDATION

PROPOSED 1No. APM5930 CABINET TO BE INSTALLED ON PROPOSED ROOT FOUNDATION

ELEVATION A

PROPOSED 12No. ANTENNA APERTURES TO BE INSTALLED ON PROPOSED STREETWORKS MONOPOLE

PROPOSED 20m HIGH STREETWORKS MONOPOLE, TO BE INSTALLED APPROXIMATELY 145m FROM THE EXISTING LOCATION AT NGR E: 507437 N: 182813

PROPOSED DIPLEXER CABINET TO BE INSTALLED ON PROPOSED ROOT FOUNDATION

 
PROPOSED 1No. WILTSHIRE CABINET TO BE INSTALLED ON PROPOSED ROOT FOUNDATION

PROPOSED 1No. HUAWEI CABINET TO BE INSTALLED ON PROPOSED ROOT FOUNDATION

SIGN BOARD

LIGHT POLE

PROPOSED MAX CONFIGURATION SITE PLAN



SITE CAPACITY & LEAD OPERATOR			
A	B	C	LEAD
HS2	HS2	HS2	H3G

Master: M001

Date: 09/04/2020

Drawn: J.S.Divya

Checked: T. Clifford

Approved: M. Venner

MBNL / EE / H3G

09/04/2020

J.S.Divya

T. Clifford

M. Venner

Project: T&A

Revision / Upgrade Description: First Issue

ACQ

Hutchison 3G UK Limited

Star House, 20 Grenfell Road

Maidenhead, SL6 1EH

Tel: 01628 765 500

Fax: 01628 765 501

H3G Base Station Information line:

0845 6043000

Available 8am-8pm Monday to Friday

8

Hatfield Business Park

Hatfield

Hertfordshire

AL10 9BW

Tel: 01707 315000

Fax: 01707 319001

MBNL

Mobile Broadband Network Limited

Sixth Floor, Thames Tower, Station Road, Reading, RG1 1LX

BEACONCOMMS

UNIT E3 PITTS CLEAVE INDUSTRIAL ESTATE, TAVISTOCK, DEVON, PL19 0PW

sales@beaconcomms.co.uk

Tel: +44 (0)1822 610610

Site Name:

BAYLISS (P98265)

Site ID:

782743

Address:

BAYLISS (P98265)

LONG LANE HILLINGDON

UXBRIDGE

LONDON: HILLINGDON

UB10 0EG

Title:

216 MAX CONFIGURATION SITE PLAN - SHEET 2

Project:

T & A

Purpose of Issue:

GENERAL ARRANGEMENT

EE Cell ID: 70464

MBNL Cell ID: HGN038

3UK Cell ID: UB0104


Master Drawing No: 782743_HGN038_70464_UB0104_M001

Issue: A

NOTE:
EXISTING BT & TX TO BE RELOCATED TO NEW MK5 LAC.
EXISTING SINGLE PHASE 63A POWER SUPPLY WILL BE
UPGRADED TO THREE PHASE 100A SUPPLY WITH IN MK5 LAC

Antenna Aperture ID	Proposed 4G/5G Bearing	Operator: Shared/ EE/H3G
A1	60°	H3G
A2	60°	EE
A3	60°	EE/H3G
A4	60°	EE/H3G
B1	180°	H3G
B2	180°	EE
B3	180°	EE/H3G
B4	180°	EE/H3G
C1	300°	H3G
C2	300°	EE
C3	300°	EE/H3G
C4	300°	EE/H3G

NOTES:
1. ALL DIMENSIONS IN MM UNLESS OTHERWISE NOTED.

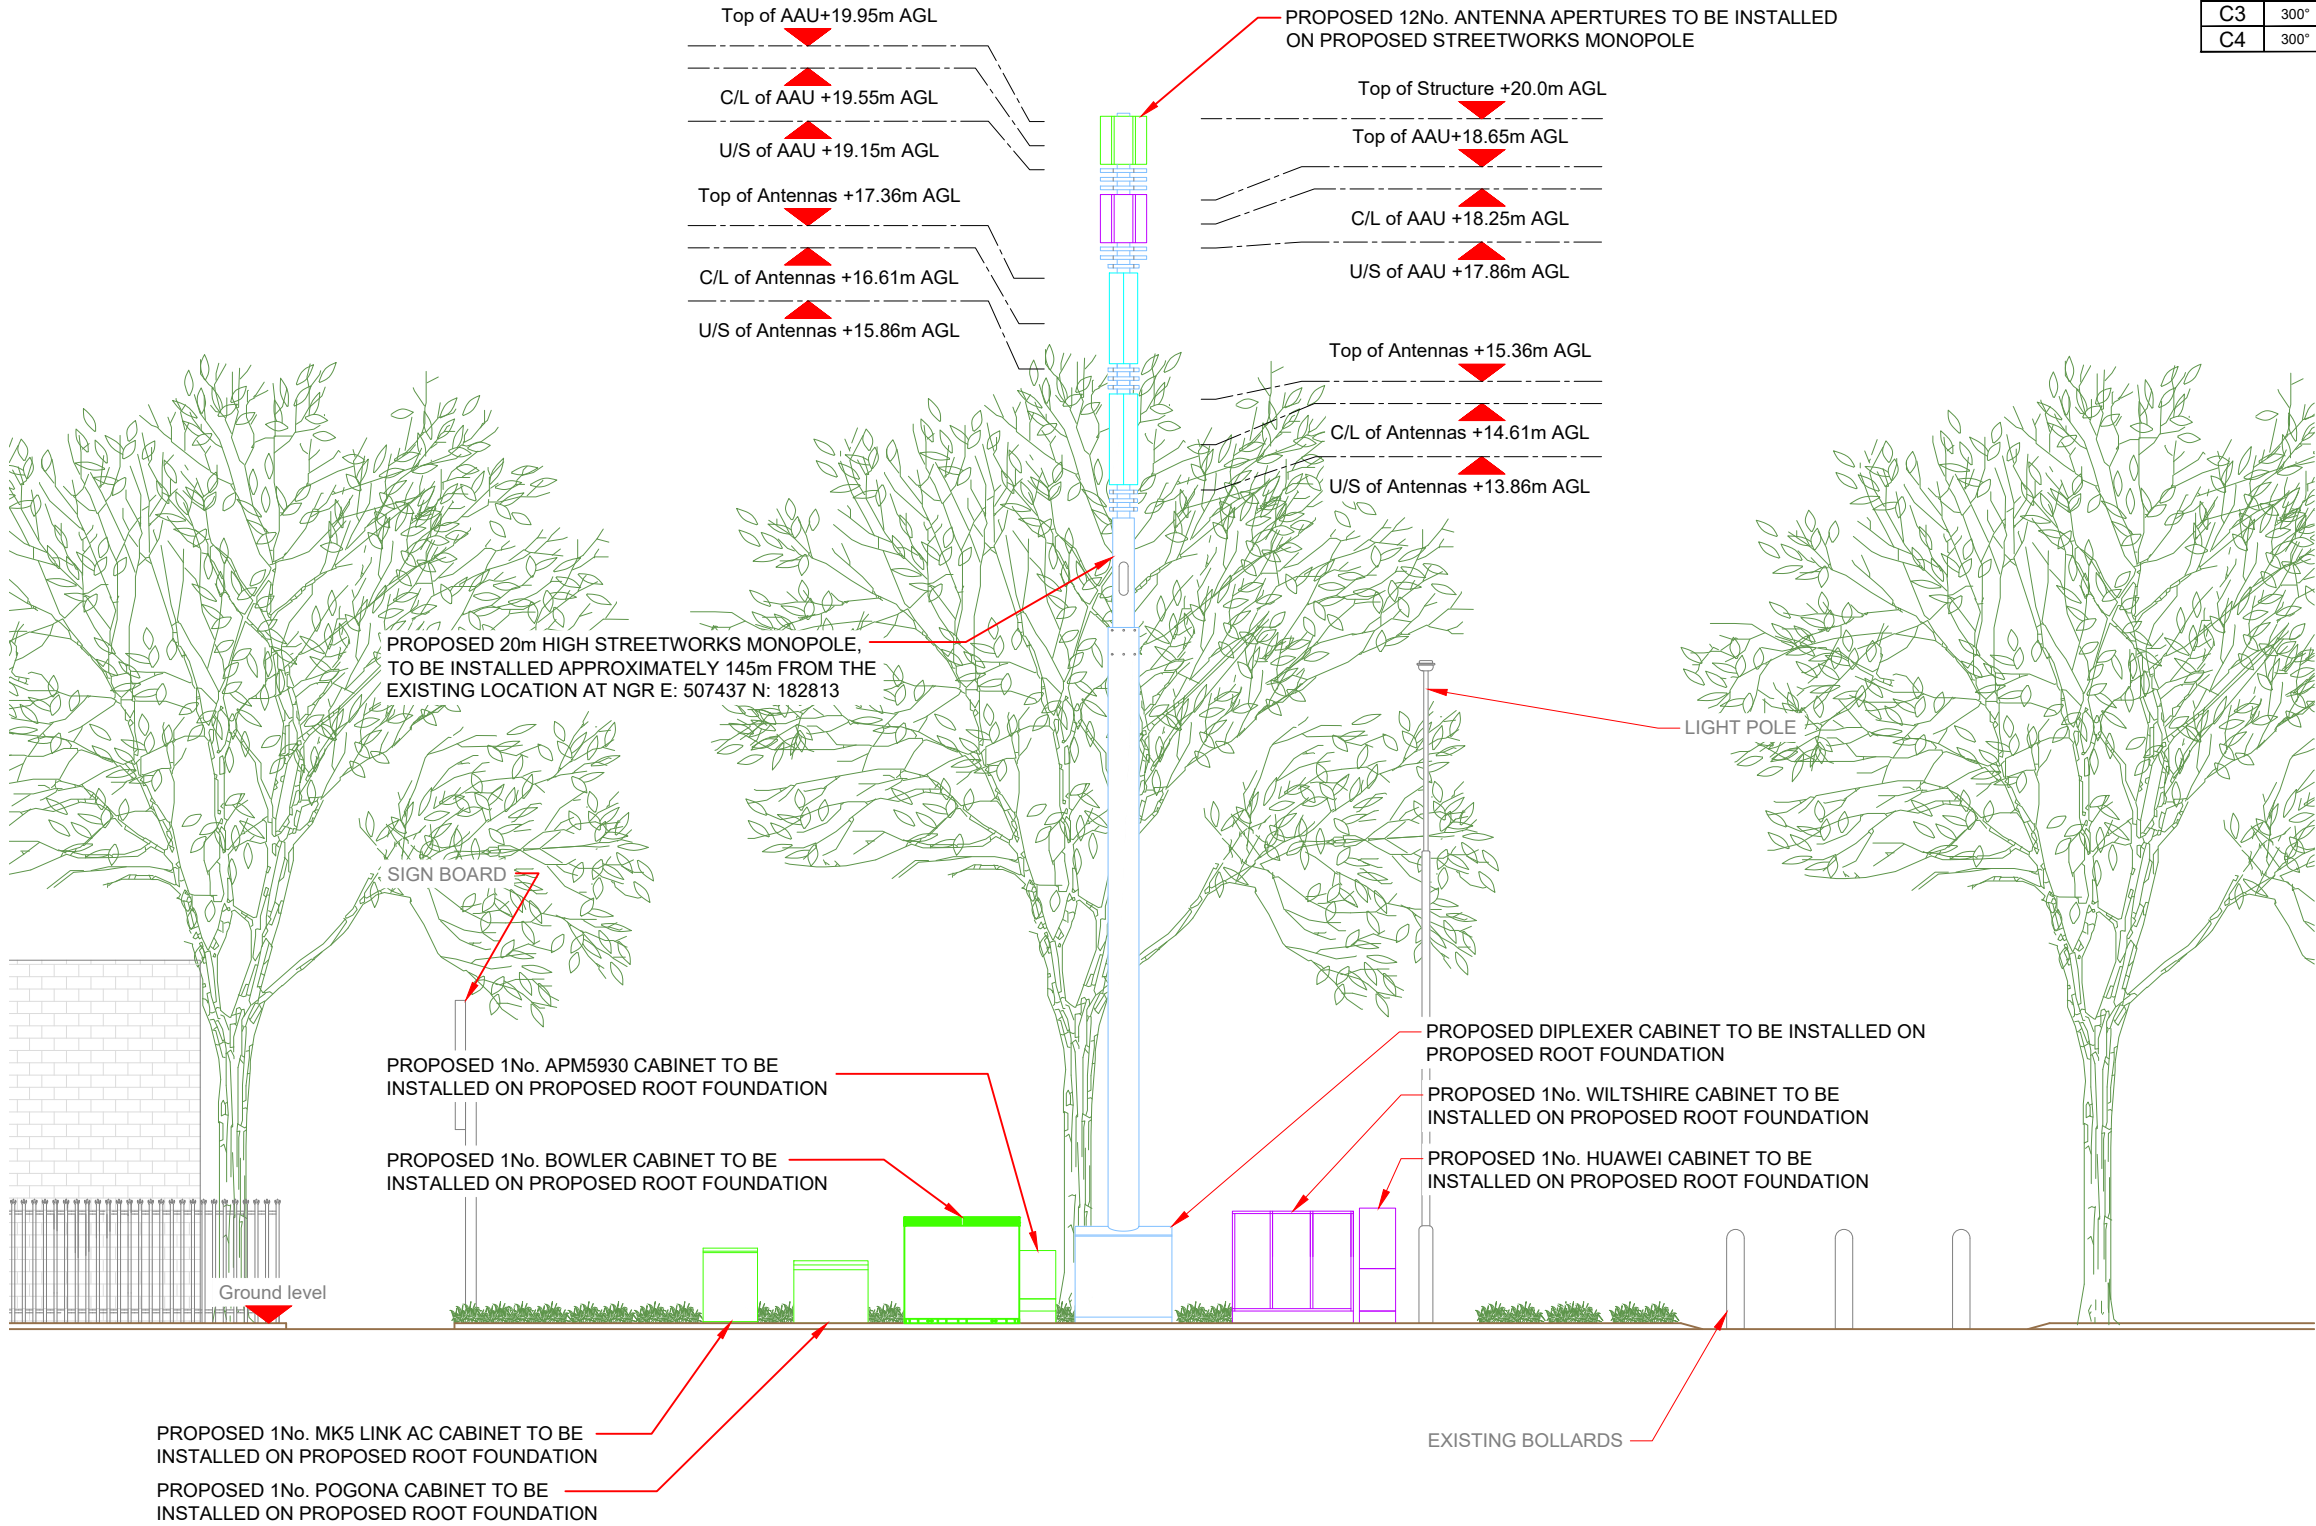

Master: M001

Date: 09/04/2020

Drawn: J.S.Divya

Checked: T. Clifford

Approved: M. Venner

MBNL

09/04/2020

J.S.Divya

T. Clifford

M. Venner

Project: T&A

Revision / Upgrade Description: First Issue

Purpose of Issue: Planning

Issue: A

ACQ

Hutchison 3G UK Limited
Star House, 20 Grenfell Road
Maidenhead, SL6 1EH
Tel: 01628 765 000
Fax: 01628 765 001
H3G Base Station Information line:
0845 6043000
Available 8am-8pm Monday to Friday

3

Hatfield Business Park
Hatfield
Hertfordshire
AL10 9BW
Tel: 01707 315000
Fax: 01707 319001

MBNL

Mobile Broadband Network Limited
Sixth Floor, Thames Tower, Station Road, Reading, RG1 1LX

BEACONCOMMS

UNIT E3 PITTS CLEAVE INDUSTRIAL ESTATE, TAVISTOCK, DEVON, PL19 0PW
sales@beaconcomms.co.uk
Tel: +44 (0)1822 610610

Site Name: BAYLISS (P98265)

Site ID: 782743

Address: BAYLISS (P98265)
LONG LANE HILLINGDON
UXBRIDGE
LONDON: HILLINGDON
UB10 0EG

Title: 266 MAX CONFIGURATION ELEVATION - SHEET 2

Project: T & A

Purpose of Issue: GENERAL ARRANGEMENT

EE Cell ID: 70464

MBNL Cell ID: HGN038

3UK Cell ID: UB0104

Master Drawing No: 782743_HGN038_70464_UB0104_M001

Issue: A

SITE CAPACITY & LEAD OPERATOR			
A	B	C	LEAD
HS2	HS2	HS2	H3G