


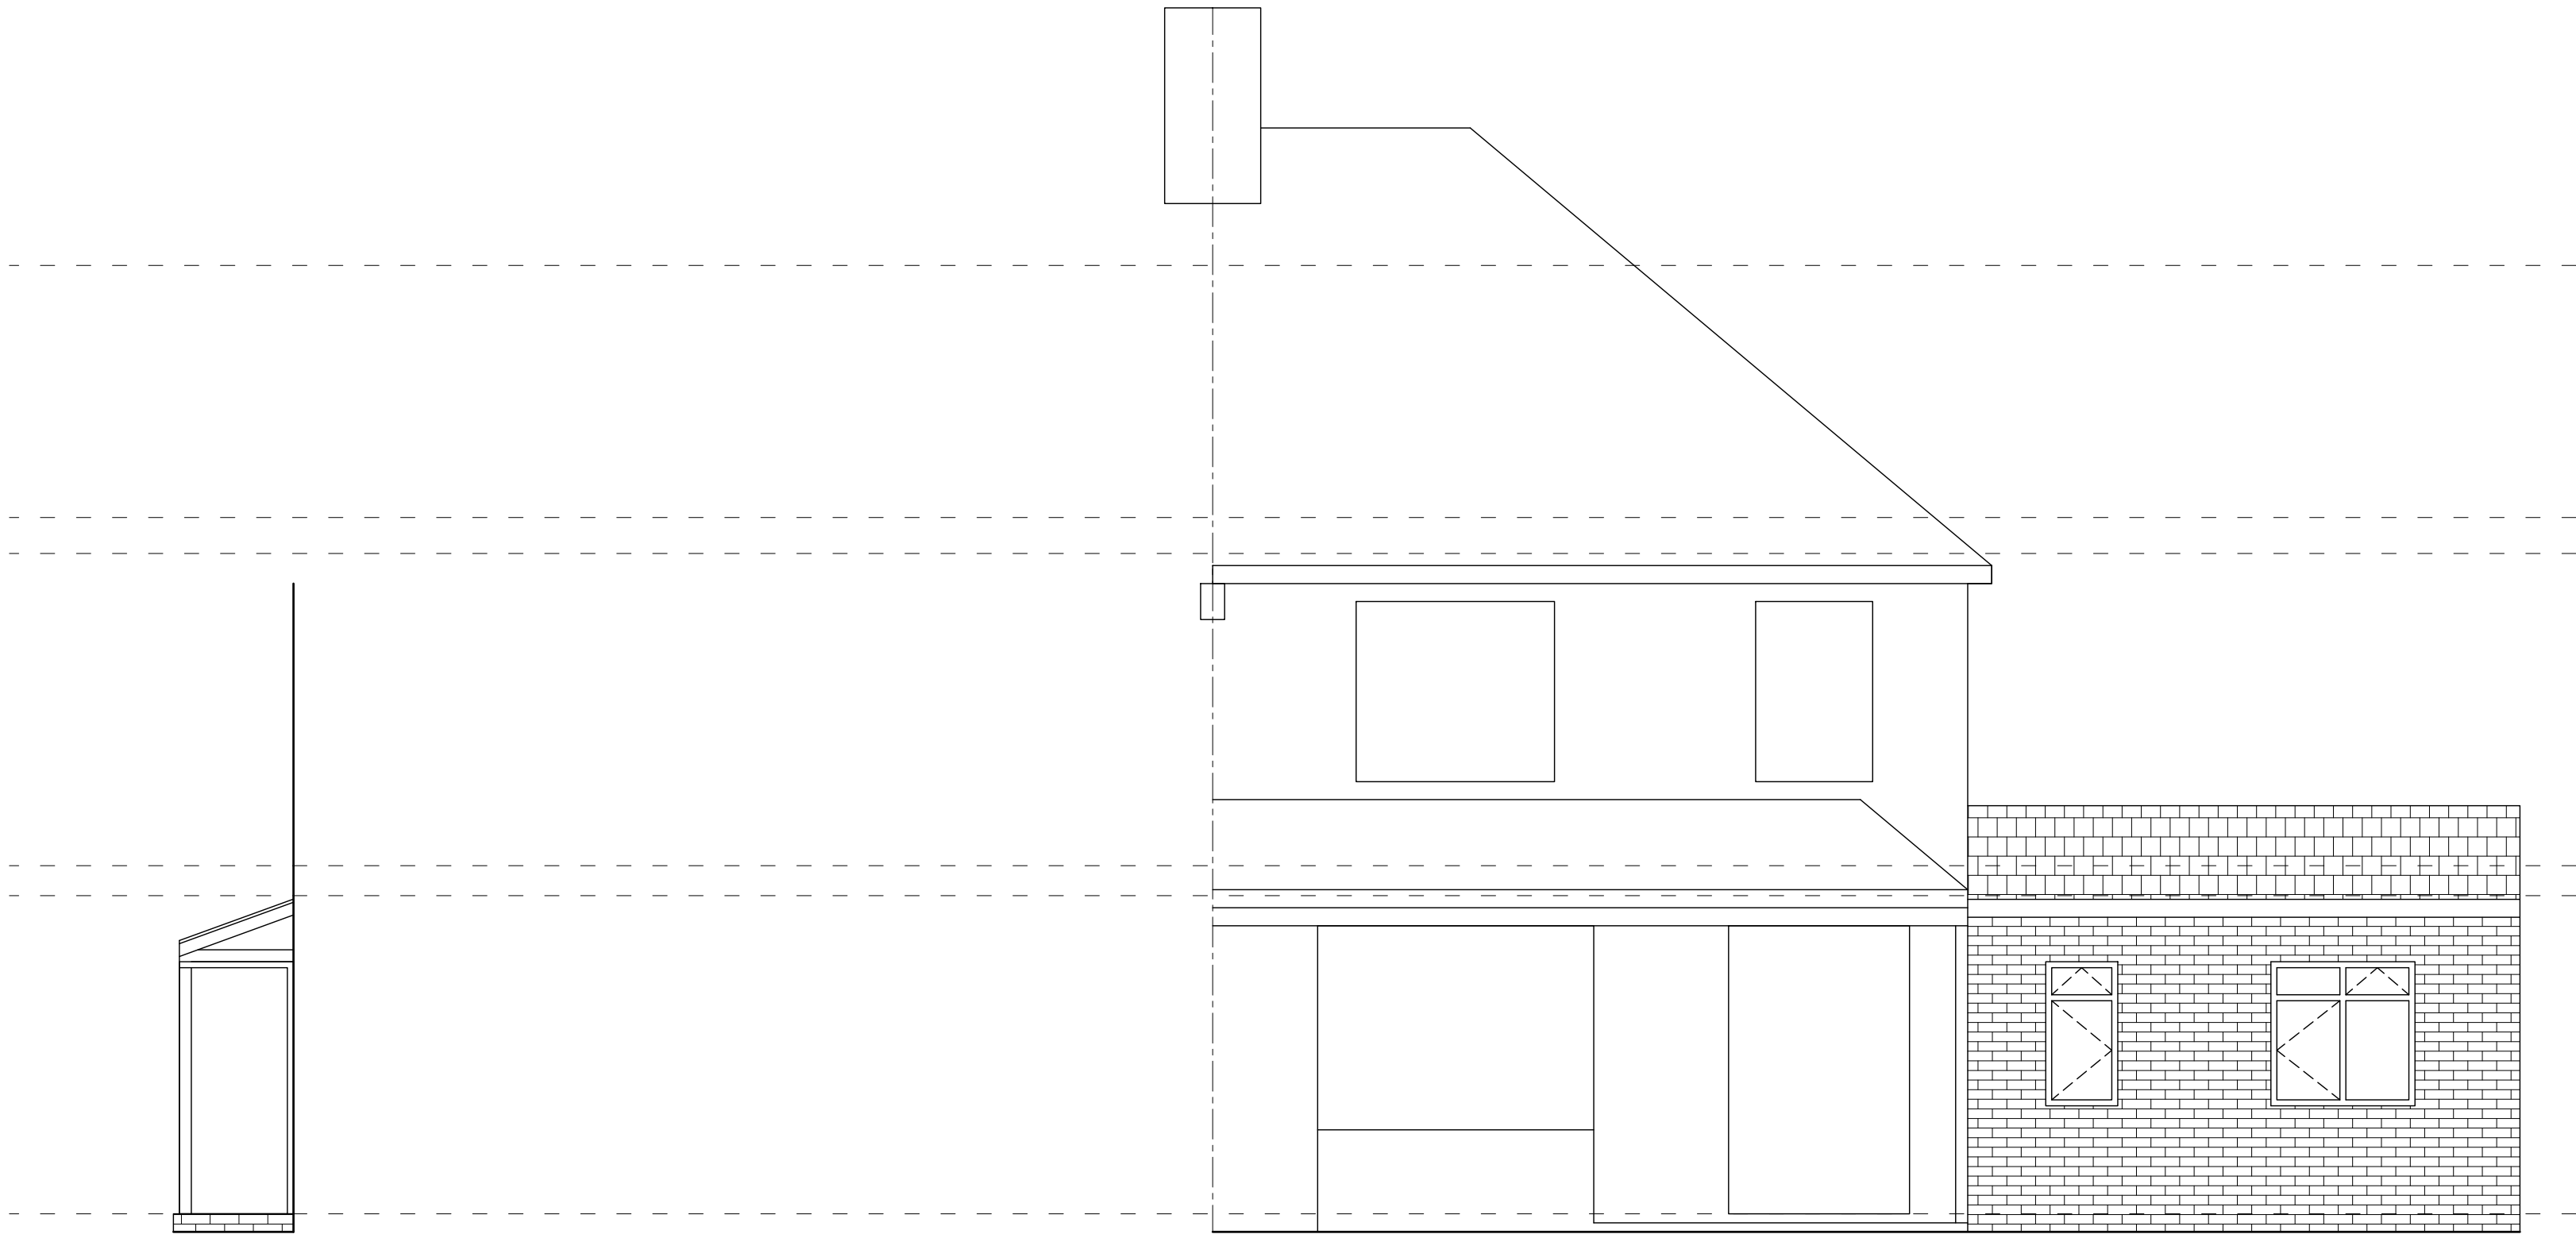

PROPOSED FLANK ELEVATION

PROPOSED FRONT ELEVATION



PROPOSED FLANK ELEVATION

PROPOSED REAR ELEVATION

GENERAL NOTES

1. THE CONTRACTOR MUST CHECK ALL DIMENSIONS ON SITE BEFORE COMMENCING WORK
2. ANY DISCREPANCIES MUST BE IMMEDIATELY BROUGHT TO THE ATTENTION OF THE DESIGNER
3. ALL WORK MUST CONFORM TO CURRENT BUILDING REGULATIONS, BRITISH STANDARDS & CODES OF PRACTICE AND NHBC STANDARDS
4. THESE DRAWINGS ARE TO BE READ IN CONJUNCTION WITH ALL RELEVANT DESIGNER, ENGINEER OR SPECIALIST DRAWINGS AND SPECIFICATIONS
5. ALL DIMENSIONS ARE IN MILLIMETERS UNLESS STATED OTHERWISE
6. ALL MATERIALS ARE TO BE USED AND INSTALLED IN STRICT COMPLIANCE WITH THE RELEVANT MANUFACTURER'S RECOMMENDATIONS
7. THE CONTRACTOR IS RESPONSIBLE FOR PROVIDING ALL NECESSARY TEMPORARY SUPPORT TO THE BUILDING AND ANY ADJACENT STRUCTURES
8. ALL CONSTRUCTION MUST BE BUILT WITHIN THE ACTUAL PROPERTY BOUNDARIES UNLESS PARTY WALL AGREEMENT ALLOWS OTHERWISE

HATCHLINE LEGEND

- concrete
demolish
above/beyond
brickwork
boundary
drain
blockwork
insulation/
stud partition

DRAINAGE ABBREVIATIONS

- mh = manhole
ic = inspection chamber
re = rodding eye
g = gully
svp = soil vent pipe
rwp = rain water pipe
ss = stub stack
rainwater drainage to contractor design
electrical layout to client design

REVISION	DESCRIPTION	DATE
----------	-------------	------



DRAW AND PLAN

T: 020 8243 8779

E: info@drawandplan.com

W: www.drawandplan.com

Location

**15 MYRTLE AVENUE RUISLIP
HILLINGDON
HA4 8SA**

Drawing title

**GENERAL ARRANGEMENT
NON MATERIAL AMENDMENT**

Date	Scale	
20/06/2023	1:50@A1	
Job no.	Dwg no.	Revision
23023	PGA012	-
1:50		
1:100		
1:200		
1:500		