


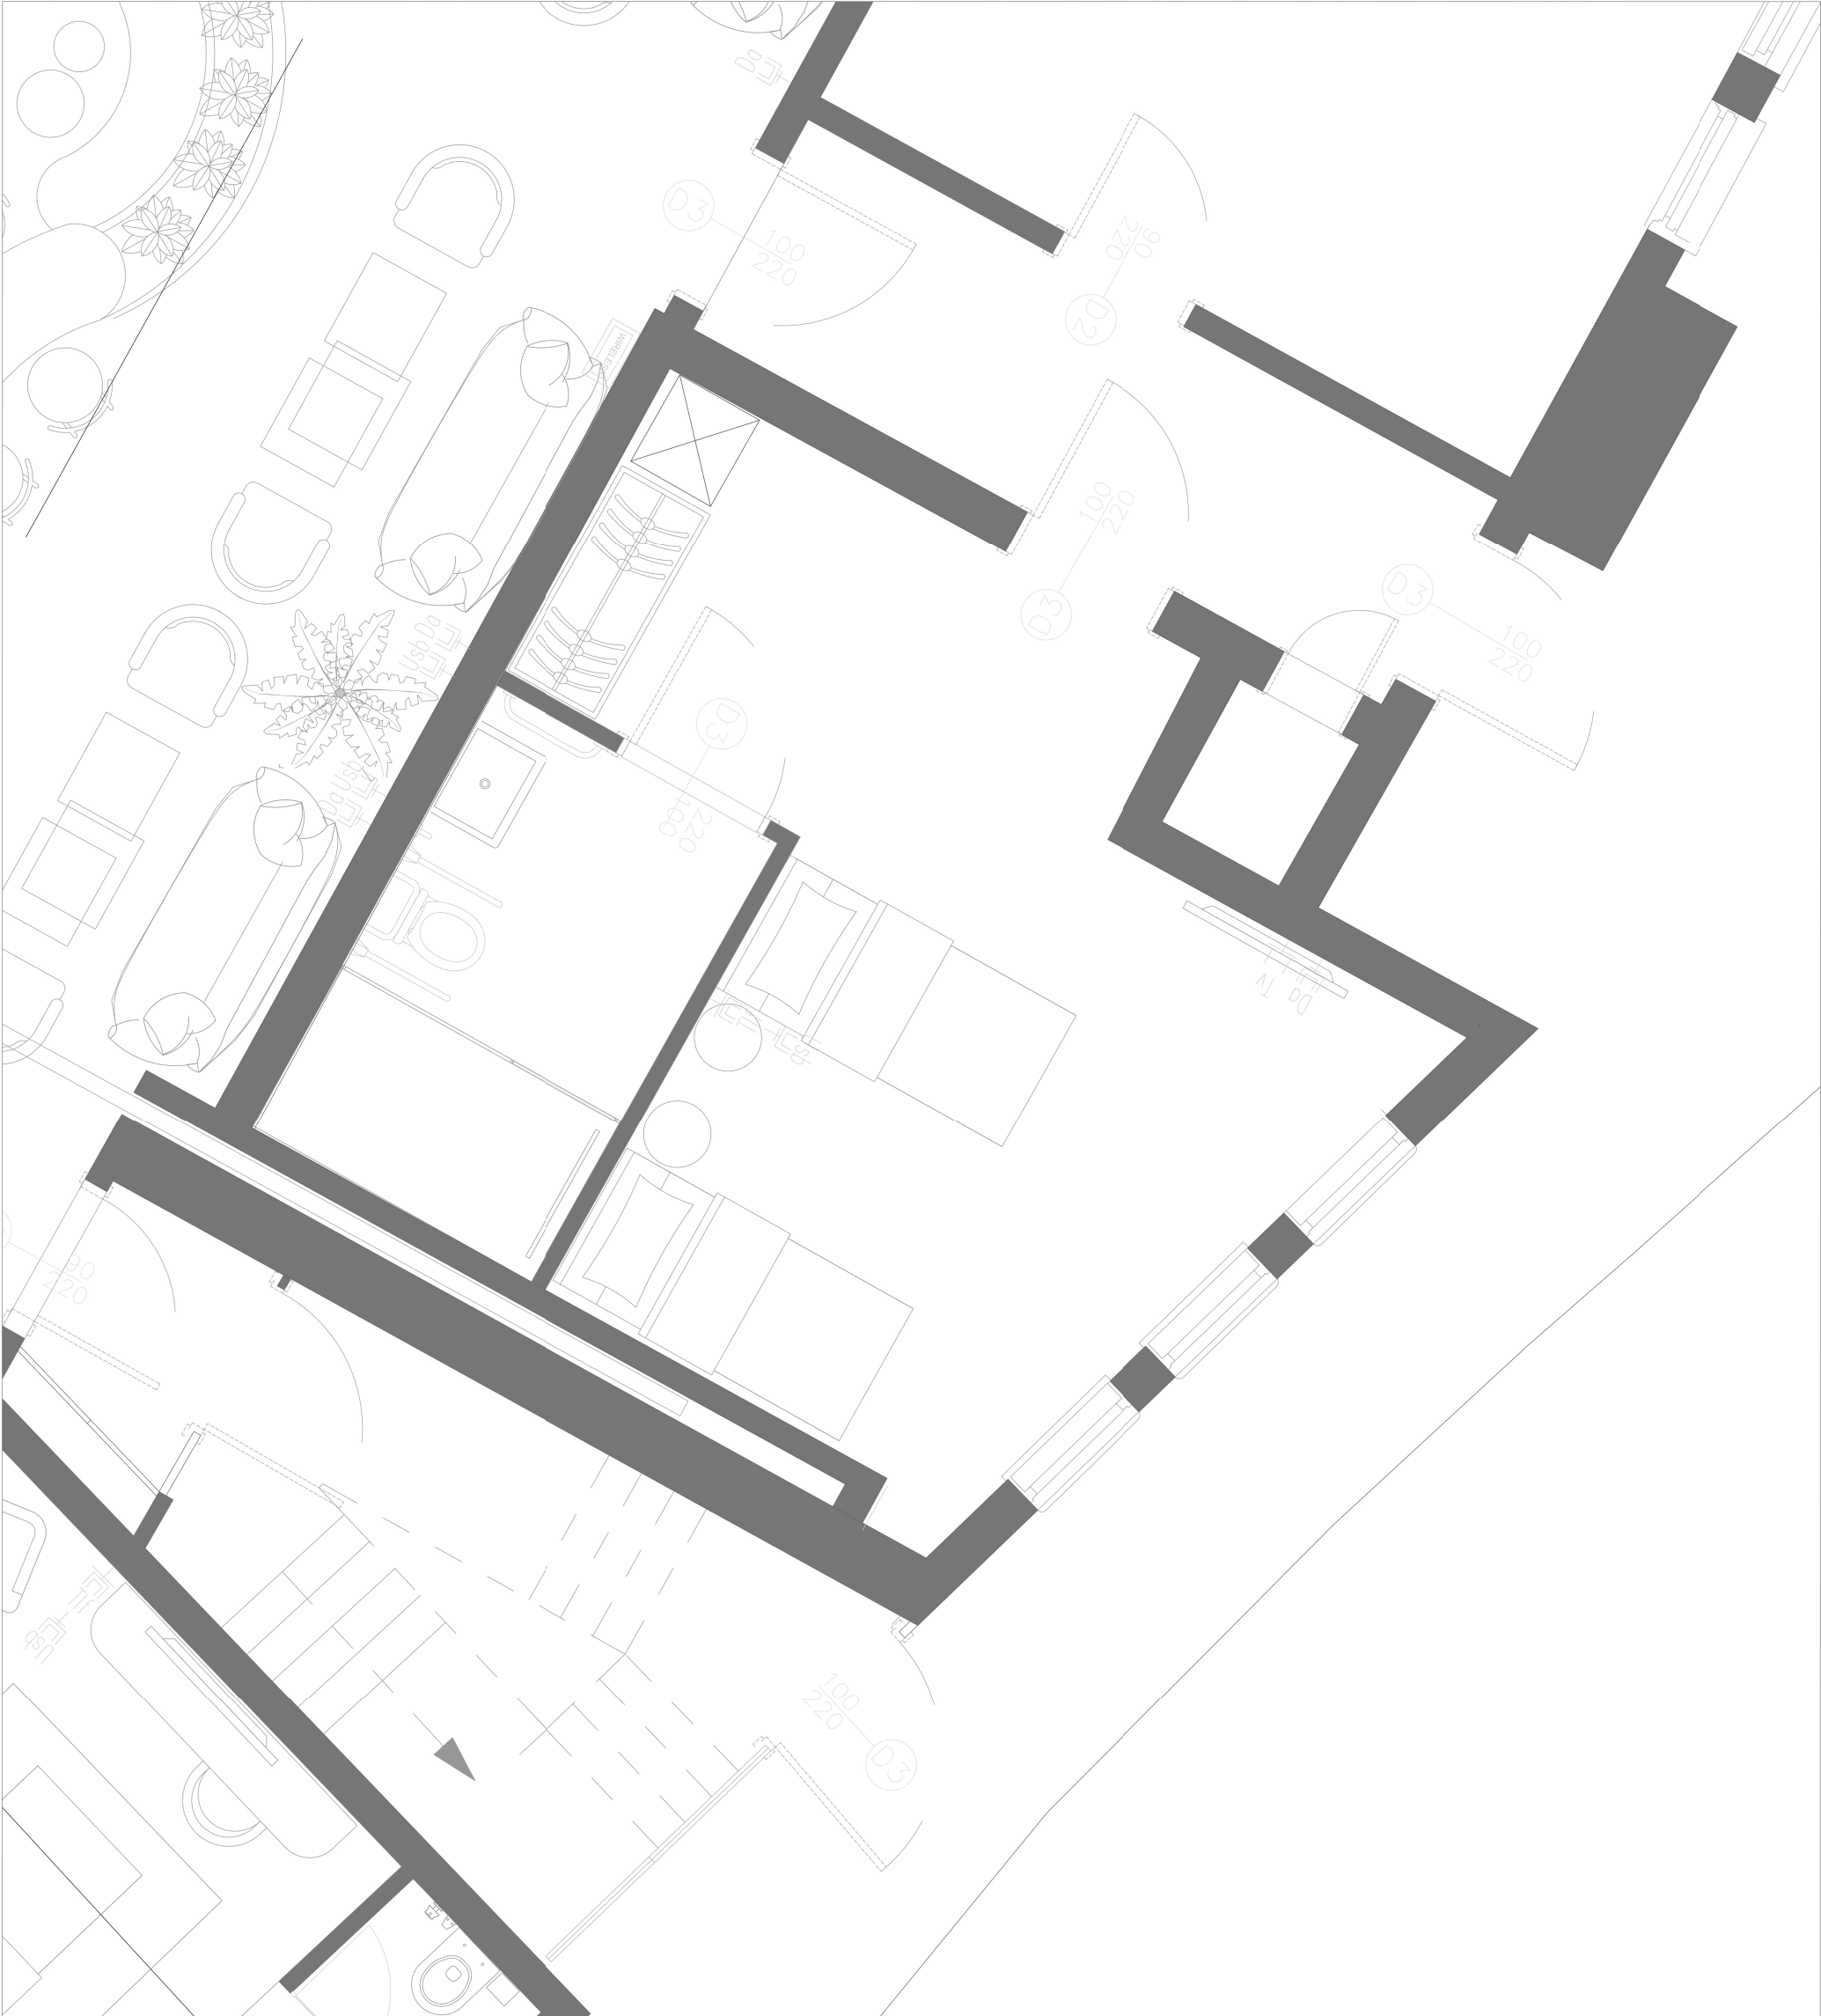

SYMBOL LEGEND		
SYMBOLS	DESCRIPTION	HEIGHT
DATA		H-110
USB		H-110
TELEPHONE		H-110
TV		H-110

BD

architects

busedoston

architects

Busedoston Architects

Address : Küçükbakkalköy


Yeniyei ÇkmazıNc: 1

Web : www.busedoston.com

+90 212 265 1 365

project@busedoston.com

www.busedoston.com

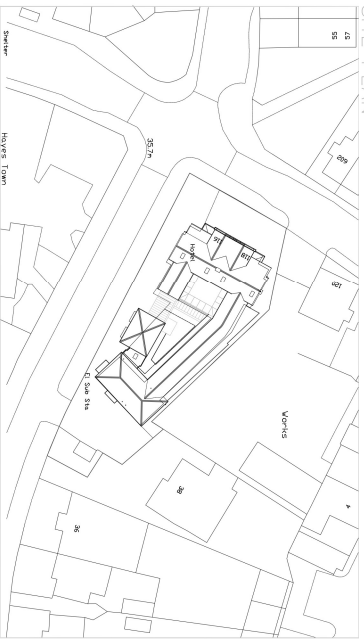

Project Name		Sheet Name	
ROSEMARY HOTEL PROJECT		TV-DATA PLAN	
Project Number	50	Date	13.07.2022
Sheet Name	DISABLED ROOM PLAN	Drawn by	Şeyma Keserci
		Revision	01