

- NOTES:
- ALL DIMENSIONS IN MM UNLESS OTHERWISE NOTED.

Master:	MBNL / EE:	Project:	Purpose of Issue:	Issue:
M003	MBNL	5G UNILATERAL	Planning	C
Date:	03/11/2021	Revision / Upgrade Description:		
Drawn:	CDN	Pole location amended		
Checked:	DH			
Approved:	SD			
Master:	MBNL / EE:	Project:	Purpose of Issue:	Issue:
M002	MBNL	5G UNILATERAL	Planning	B
Date:	24/08/2020	Revision / Upgrade Description:		
Drawn:	CDN	Pole Height reduced to 15m		
Checked:	DH			
Approved:	SD			
Master:	MBNL / EE:	Project:	Purpose of Issue:	Issue:
M001	MBNL	5G UNILATERAL	Planning	A
Date:	17/07/2020	Revision / Upgrade Description:		
Drawn:	CDN	First Issue - Site nomination dated: TBC		
Checked:	DH			
Approved:	SD			

**CK Hutchison
Networks (UK)
Limited**
Great Brighams Mead,
Vastern Road, Reading,
Berkshire, England,
RG1 8DJ



WHP Telecoms
Unit 1 Maple Park,
Low Fields Avenue, Leeds
LS12 6HH
Tel: 01133023550
e-mail: info@whptelecoms.com

Site Name:
HORTON ROAD STREETWORKS

Site ID:
HGN12147

Address:
**HORTON ROAD, CROWN TRADE PARK,
LONDON BOROUGH OF HILLINGDON,
LONDON, COLHAM GREEN,
GREATER LONDON, ENGLAND,
UB7 8HT**

Title:
100 EXISTING SITE PLAN

Project:
5G UNILATERAL


Purpose of Issue:
PLANNING

EE Cell ID:	MBNL Cell ID:	Cell ID:
N/A	N/A	N/A
Master Drawing No:		Issue:
HGN12147_M003		C


100mm

150mm

10mm

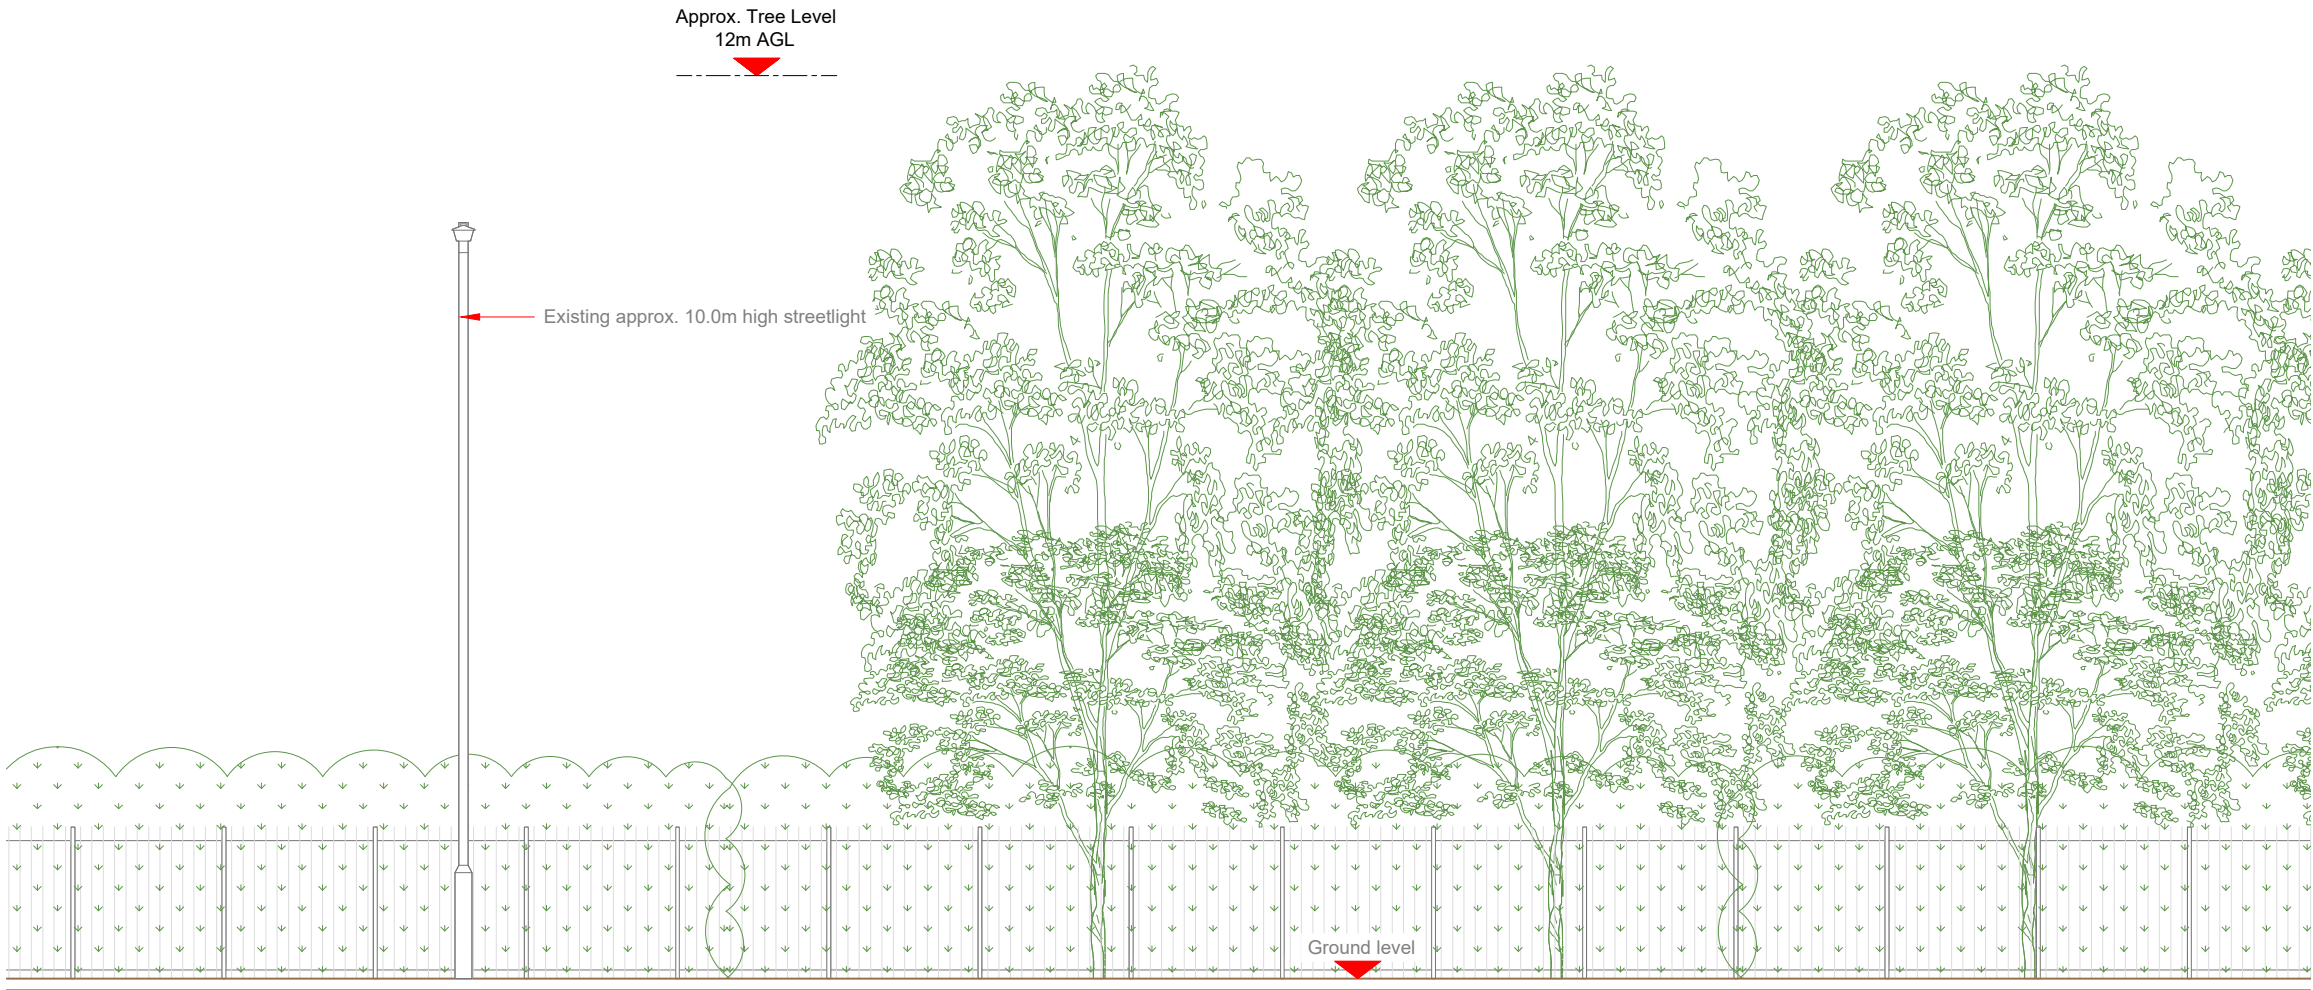


EXISTING ELEVATION A

 

- NOTES:
1. ALL DIMENSIONS IN MM UNLESS OTHERWISE NOTED.

Master:	MBNL / EE:	Project:	Purpose of Issue:	Issue:
M003	MBNL	5G UNILATERAL	Planning	C
Date:	03/11/2021	Revision / Upgrade Description:		
Drawn:	CDN	Pole location amended		
Checked:	DH			
Approved:	SD			
Master:	MBNL / EE:	Project:	Purpose of Issue:	Issue:
M002	MBNL	5G UNILATERAL	Planning	B
Date:	24/08/2020	Revision / Upgrade Description:		
Drawn:	CDN	Pole Height reduced to 15m		
Checked:	DH			
Approved:	SD			
Master:	MBNL / EE:	Project:	Purpose of Issue:	Issue:
M001	MBNL	5G UNILATERAL	Planning	A
Date:	17/07/2020	Revision / Upgrade Description:		
Drawn:	CDN	First Issue - Site nomination dated: TBC		
Checked:	DH			
Approved:	SD			

CK Hutchison
Networks (UK)
Limited
Great Brighams Mead,
Vastern Road, Reading,
Berkshire, England,
RG1 8DJ



WHP Telecoms
Unit 1 Maple Park,
Low Fields Avenue, Leeds
LS12 6HH

Tel: 01133023550
e-mail: info@whptelecoms.com

Site Name:
HORTON ROAD STREETWORKS

Site ID:
HGN12147


Address:
HORTON ROAD, CROWN TRADE PARK,
LONDON BOROUGH OF HILLINGDON,
LONDON, COLHAM GREEN,
GREATER LONDON, ENGLAND,
UB7 8HT

Title:
150 EXISTING ELEVATION A

Project:
5G UNILATERAL

Purpose of Issue:
PLANNING

EE Cell ID: N/A	MBNL Cell ID: N/A	Cell ID: N/A
Master Drawing No: HGN12147_M003		
Issue: C		

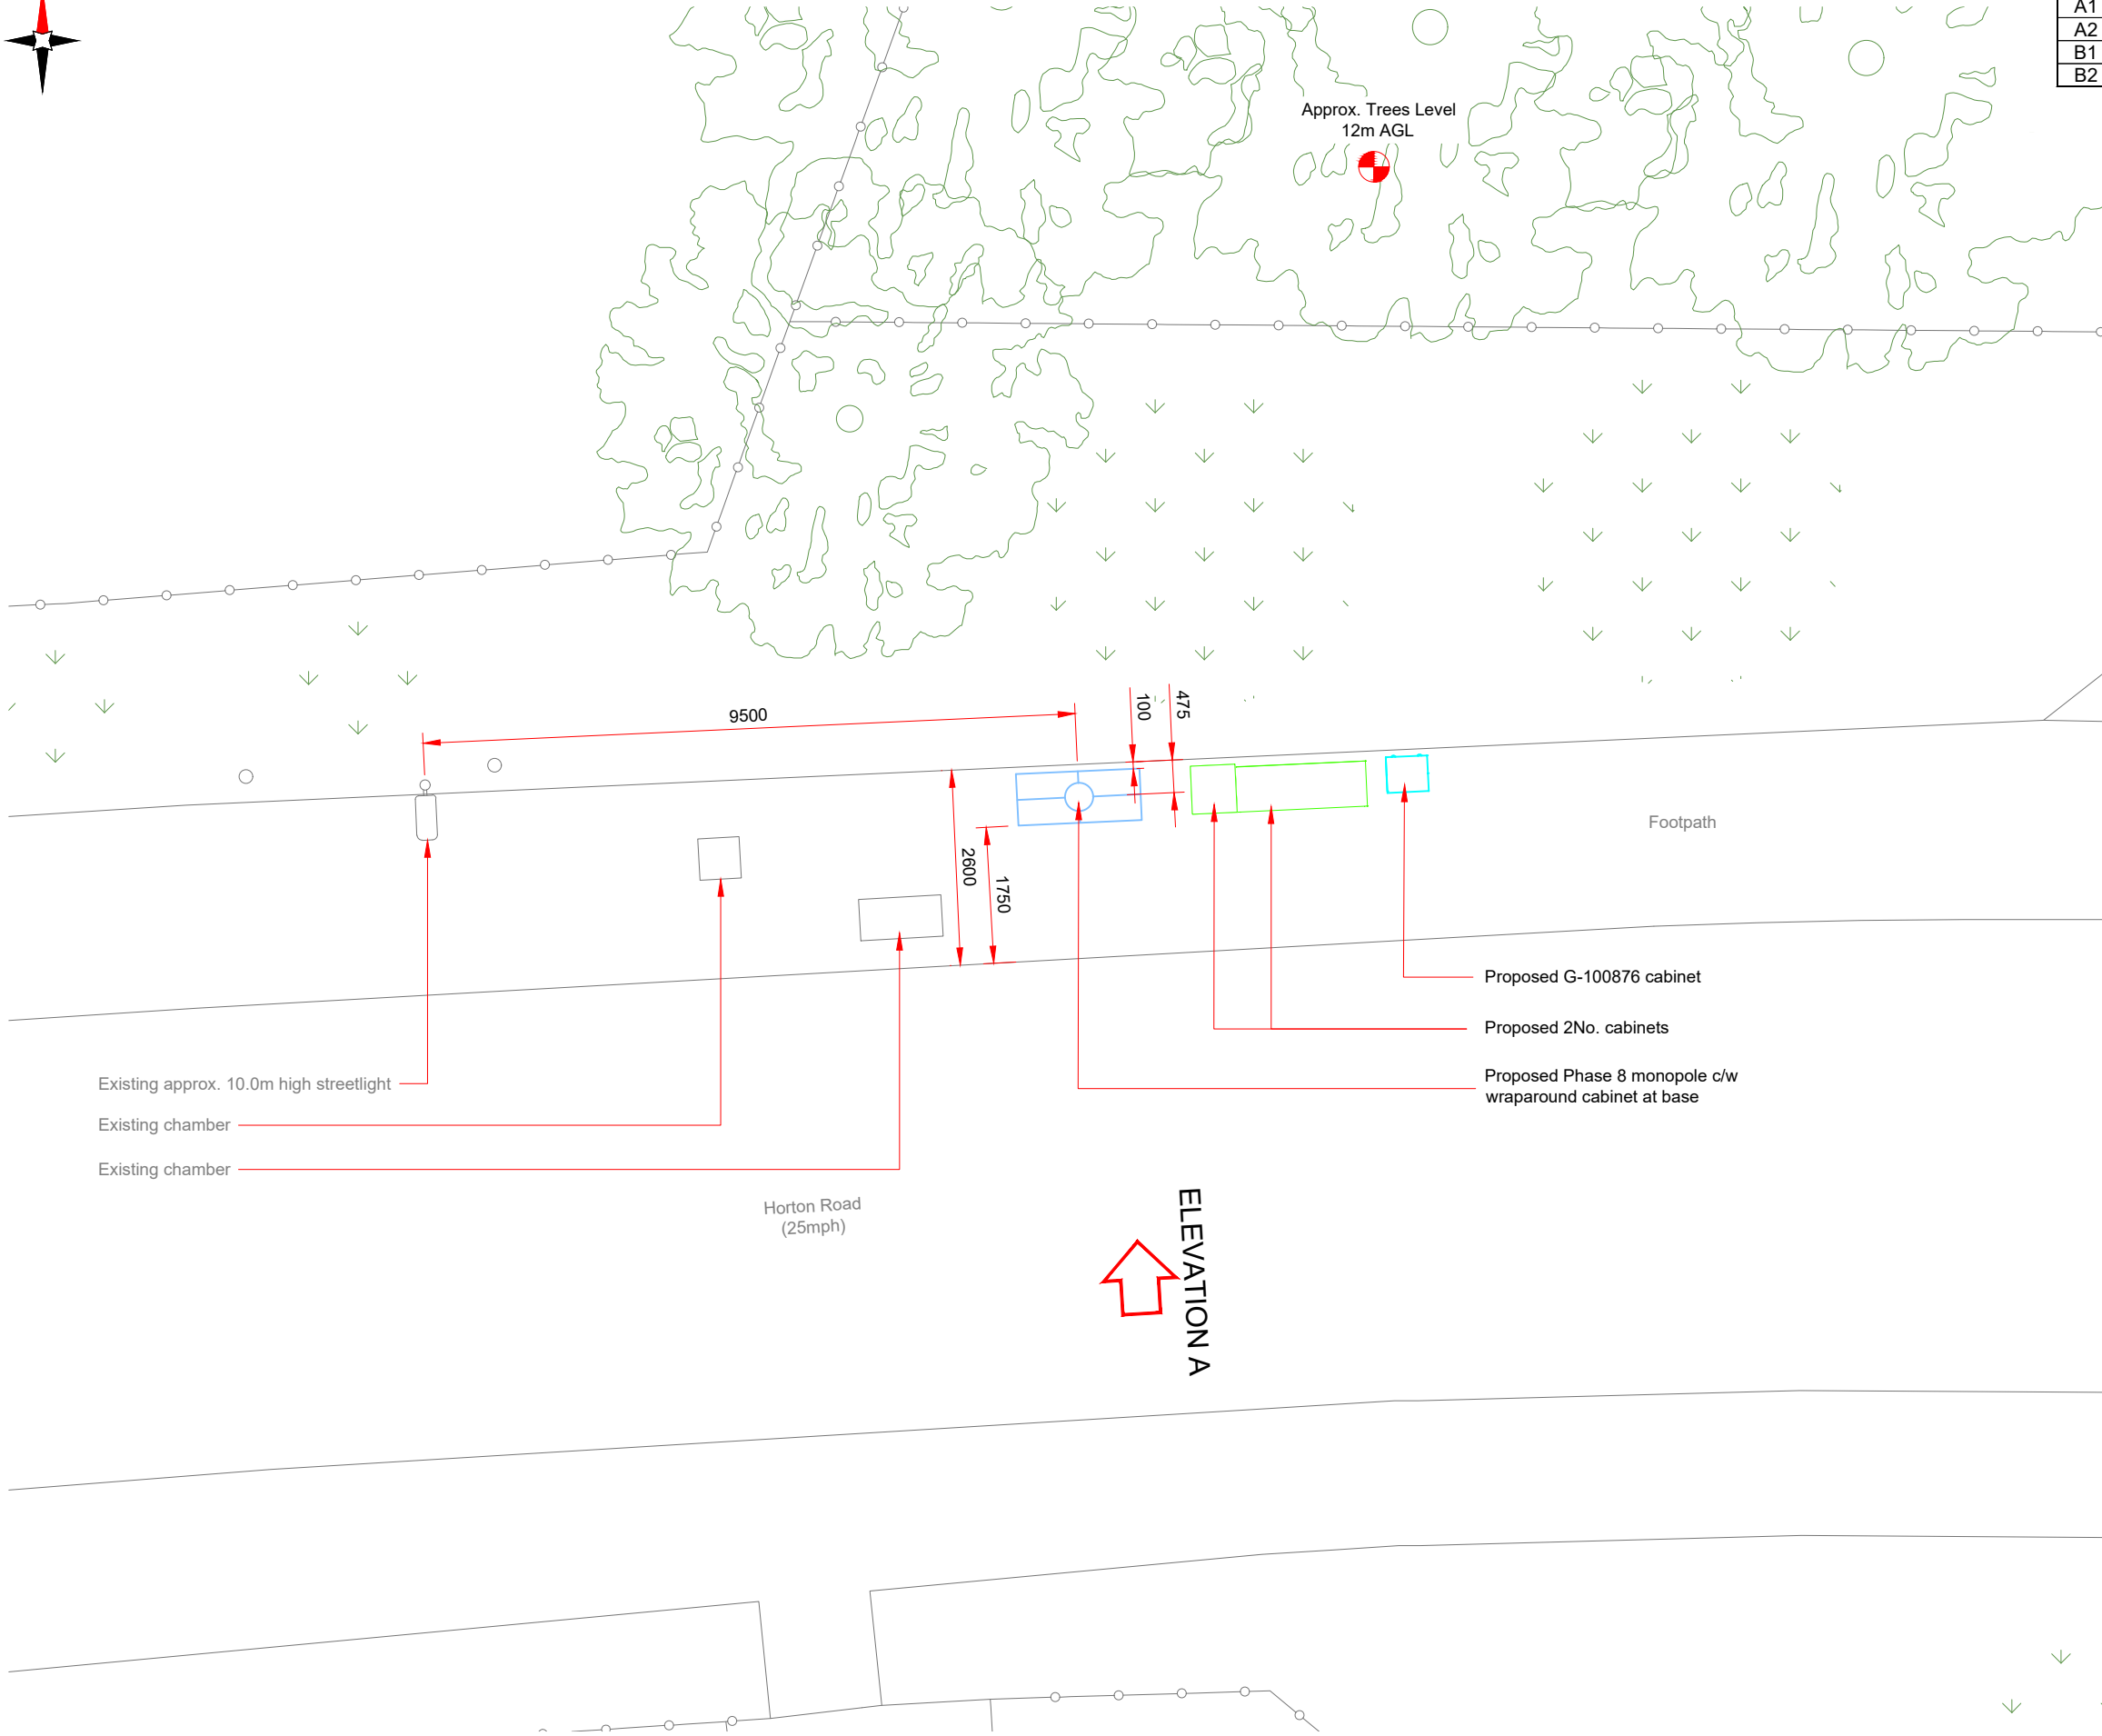

Antenna Aperture ID	Proposed 4G/5G Bearing
A1	120°
A2	120°
B1	240°
B2	240°

NOTES:


1. ALL DIMENSIONS IN MM UNLESS OTHERWISE NOTED.

Master: M003	MBNL / EE: MBNL	Project: 5G UNILATERAL	Purpose of Issue: Planning	Issue: C
Date: 03/11/2021	Drawn: CDN	Revision / Upgrade Description: Pole location amended		
Checked: DH	Approved: SD			
Master: M002	MBNL / EE: MBNL	Project: 5G UNILATERAL	Purpose of Issue: Planning	Issue: B
Date: 24/08/2020	Drawn: CDN	Revision / Upgrade Description: Pole Height reduced to 15m		
Checked: DH	Approved: SD			
Master: M001	MBNL / EE: MBNL	Project: 5G UNILATERAL	Purpose of Issue: Planning	Issue: A
Date: 17/07/2020	Drawn: CDN	Revision / Upgrade Description: First Issue - Site nomination dated: TBC		
Checked: DH	Approved: SD			

CK Hutchison Networks (UK) Limited

Great Brighams Mead,
Vastern Road, Reading,
Berkshire, England,
RG1 8DJ

Design Consultant & Principal Contractor:



WHP Telecoms
Unit 1 Maple Park,
Low Fields Avenue, Leeds
LS12 6HH

Tel: 01133023550
e-mail: info@whptelecoms.com

Site Name:

HORTON ROAD STREETWORKS

Site ID:

HGN12147

Address:

HORTON ROAD, CROWN TRADE PARK,
LONDON BOROUGH OF HILLINGDON,
LONDON, COLHAM GREEN,
GREATER LONDON, ENGLAND,
UB7 8HT

Title:

210 PROPOSED SITE PLAN

Project:

5G UNILATERAL

Purpose of Issue:

PLANNING

EE Cell ID: N/A	MBNL Cell ID: N/A	Cell ID: N/A
--------------------	----------------------	-----------------

Master Drawing No:

HGN12147_M003


Issue:

C

Antenna Aperture ID	Proposed 4G/5G Bearing
A1	120°
A2	120°
B1	240°
B2	240°

NOTES:


1. ALL DIMENSIONS IN MM UNLESS OTHERWISE NOTED.

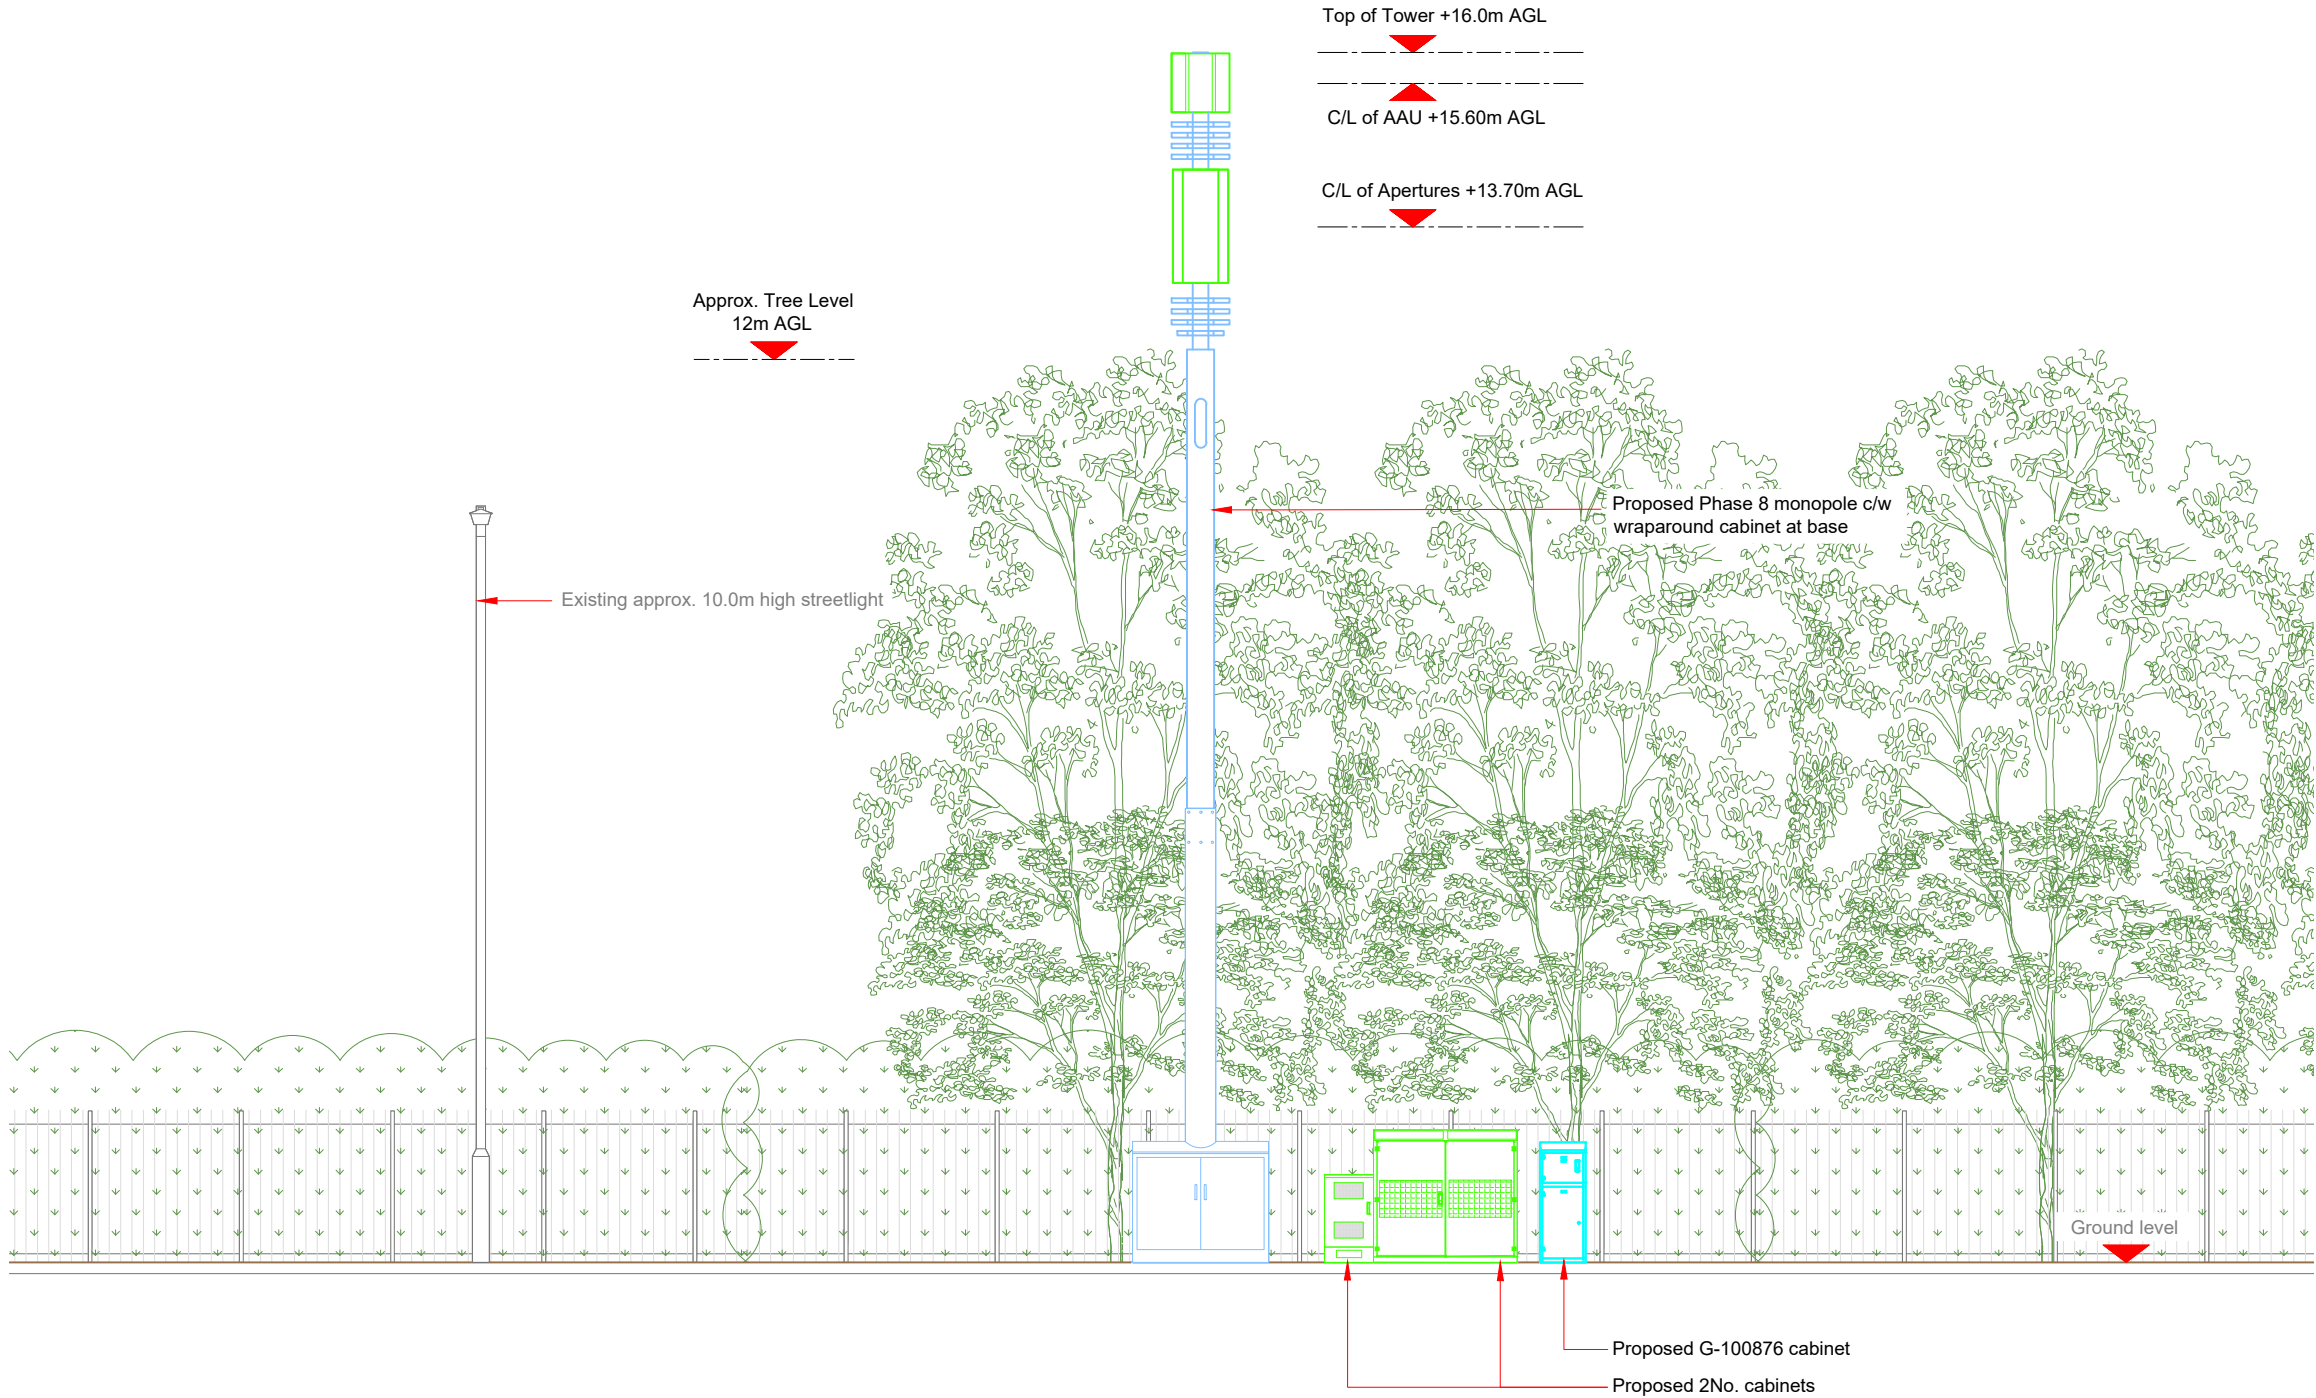

Master:	MBNL / EE:	Project:	Purpose of Issue:	Issue:
M003	MBNL	5G UNILATERAL	Planning	C
Date:	03/11/2021	Revision / Upgrade Description:		
Drawn:	CDN	Pole location amended		
Checked:	DH			
Approved:	SD			
Master:	MBNL / EE:	Project:	Purpose of Issue:	Issue:
M002	MBNL	5G UNILATERAL	Planning	B
Date:	24/08/2020	Revision / Upgrade Description:		
Drawn:	CDN	Pole Height reduced to 15m		
Checked:	DH			
Approved:	SD			
Master:	MBNL / EE:	Project:	Purpose of Issue:	Issue:
M001	MBNL	5G UNILATERAL	Planning	A
Date:	17/07/2020	Revision / Upgrade Description:		
Drawn:	CDN	First Issue - Site nomination dated: TBC		
Checked:	DH			
Approved:	SD			

CK Hutchison Networks (UK) Limited
Great Brighams Mead,
Vastern Road, Reading,
Berkshire, England,
RG1 8DJ

Design Consultant & Principal Contractor:

 **WHP Telecoms**
Unit 1 Maple Park,
Low Fields Avenue, Leeds
LS12 6HH
Tel: 01133023550
e-mail: info@whptelecoms.com

Site Name:
HORTON ROAD STREETWORKS

Site ID:
HGN12147

Address:
**HORTON ROAD, CROWN TRADE PARK,
LONDON BOROUGH OF HILLINGDON,
LONDON, COLHAM GREEN,
GREATER LONDON, ENGLAND,
UB7 8HT**

Title:
260 PROPOSED ELEVATION

Project:
5G UNILATERAL

Purpose of Issue:
PLANNING

EE Cell ID: N/A	MBNL Cell ID: N/A	Cell ID: N/A
Master Drawing No: HGN12147_M003		Issue: C