



SITE LOCATION

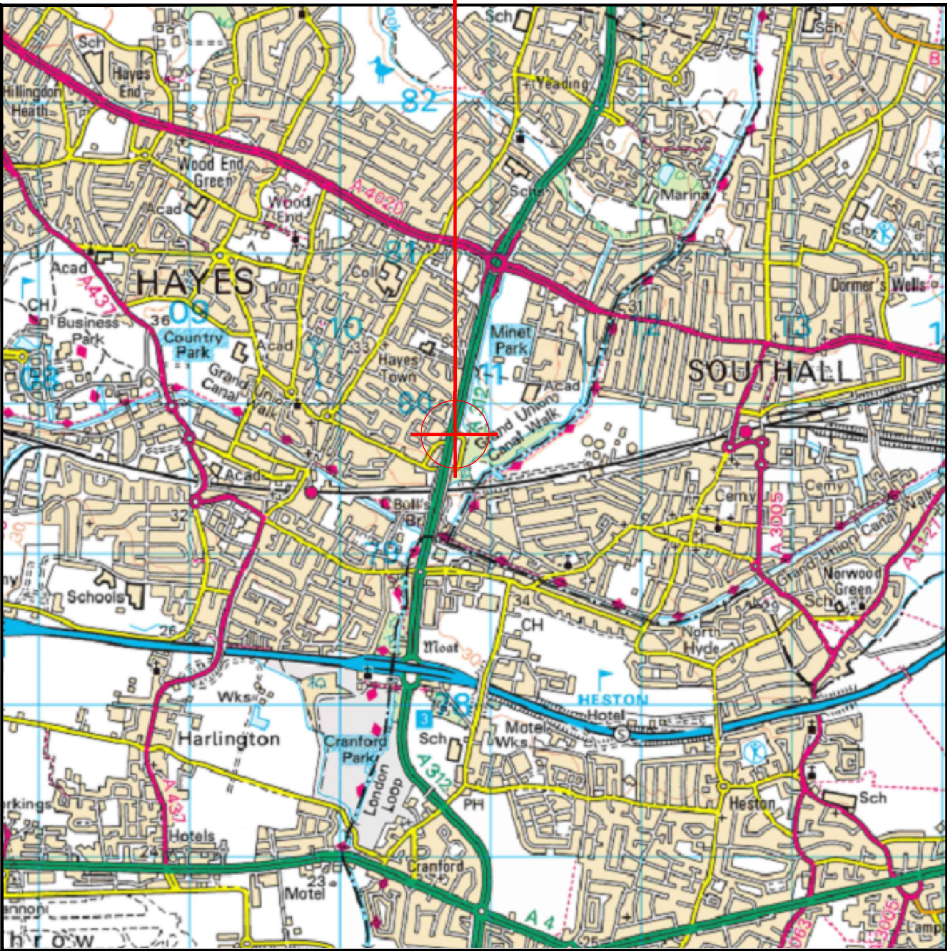

 
Reproduced by permission of Ordnance Survey on behalf of the Controller of Her Majesty's Stationary Office
All rights reserved. © Crown Copyright licence no. 100062043

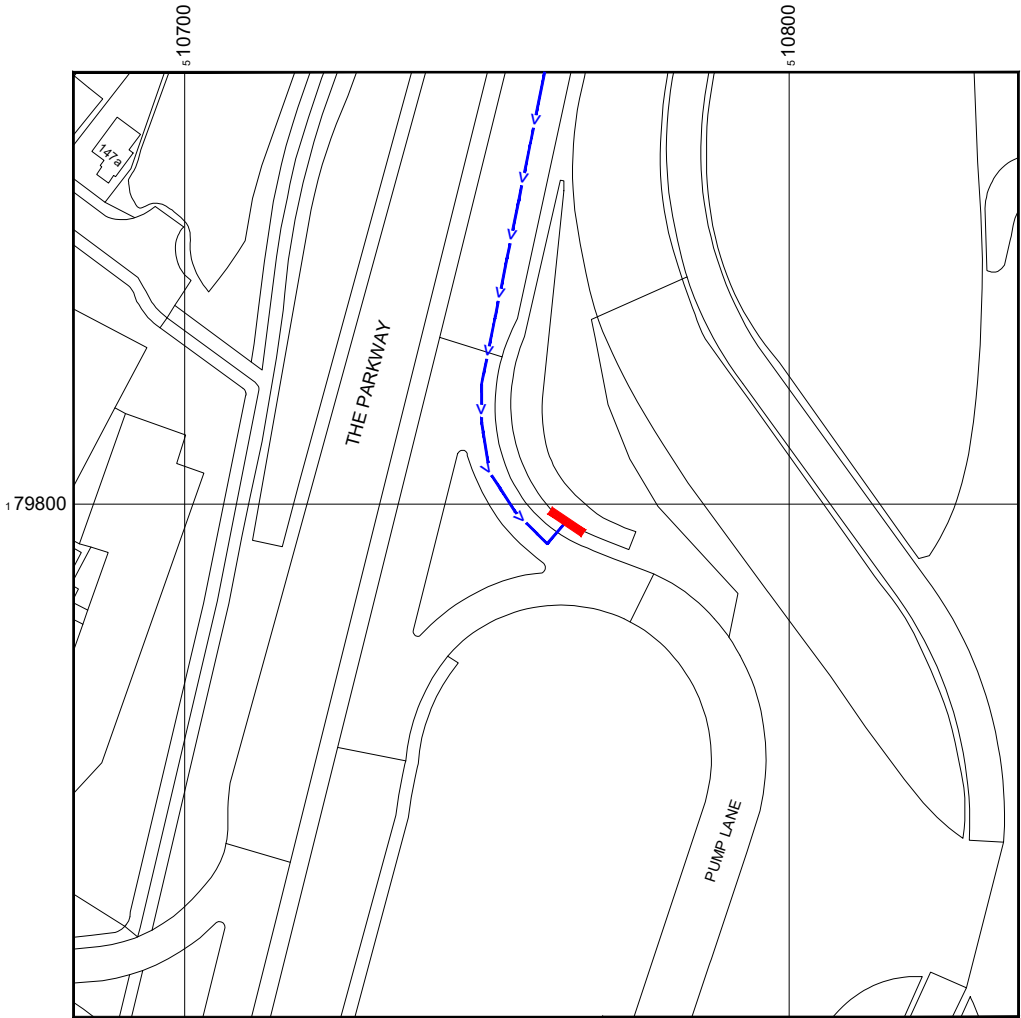

Reproduced by permission of Ordnance Survey on behalf of
the Controller of Her Majesty's Stationary Office
All rights reserved. © Crown Copyright licence no. 100062043


NGR E: 510766 N: 179799

SITE AREA PLAN



SITE PHOTOGRAPH

 SITE LOCATION PLAN



GOOGLE MAPS QR CODE

GOOGLE MAPS - <https://goo.gl/maps/52R27rxjRp8Rg8r39>

GOOGLE STREETVIEW - <https://goo.gl/maps/HkxnpSQXeXb6Tdvg6>

NOTES:

1. ALL DIMENSIONS IN MM UNLESS OTHERWISE NOTED.
- DIRECTIONS TO SITE:
Head north-west on M4. At junction 3, take the A312 exit to Heathrow Airport/Hayes/Feltham. At Cranford Parkway Interchange, take the 5th exit onto The Pkwy/A312. At the roundabout, take the 2nd exit and stay on The Pkwy/A312. Use the left 2 lanes to take the A4020 exit towards Uxbridge/Hayes/Ealing/Southall. At the roundabout, take the 4th exit onto the A312 slip road to M4/Heathrow Airport/Pump Lane Industrial Est. Merge onto The Pkwy/A312. Slight left onto Pump Ln and site location is on the left hand side.



Master:	MBNL / EE:	Project:	Purpose of Issue:	Issue:
M001	MBNL	3UK DNSW	Planning	A
Date:	20/02/2023	Revision / Upgrade Description:		
Drawn:	CDN	First Issue - Site nomination dated: TBC		
Checked:	DH			
Approved:	SD			

CK Hutchison Networks (UK) Limited

Green Park
450 Longwater Avenue
Reading
RG30 3UR

Design Consultant & Principal Contractor:



WHP Telecoms
Unit 1 Maple Park,
Low Fields Avenue, Leeds
LS12 6HH

Tel: 01133023550
e-mail: info@whptelecoms.com

Site Name: PUMP LANE STREETWORKS

Site ID: HGN24072

Address: PUMP LANE, HAYES,
LONDON BOROUGH OF HILLINGDON,
LONDON,
GREATER LONDON, ENGLAND,
UB3 3NF


Title: 002 SITE LOCATION PLAN

Project: 3UK DNSW

Purpose of Issue: PLANNING

EE Cell ID:	MBNL Cell ID:	Cell ID:
87591	HGN320	UB1053

Master Drawing No:	Issue:
HGN24072_M001	A

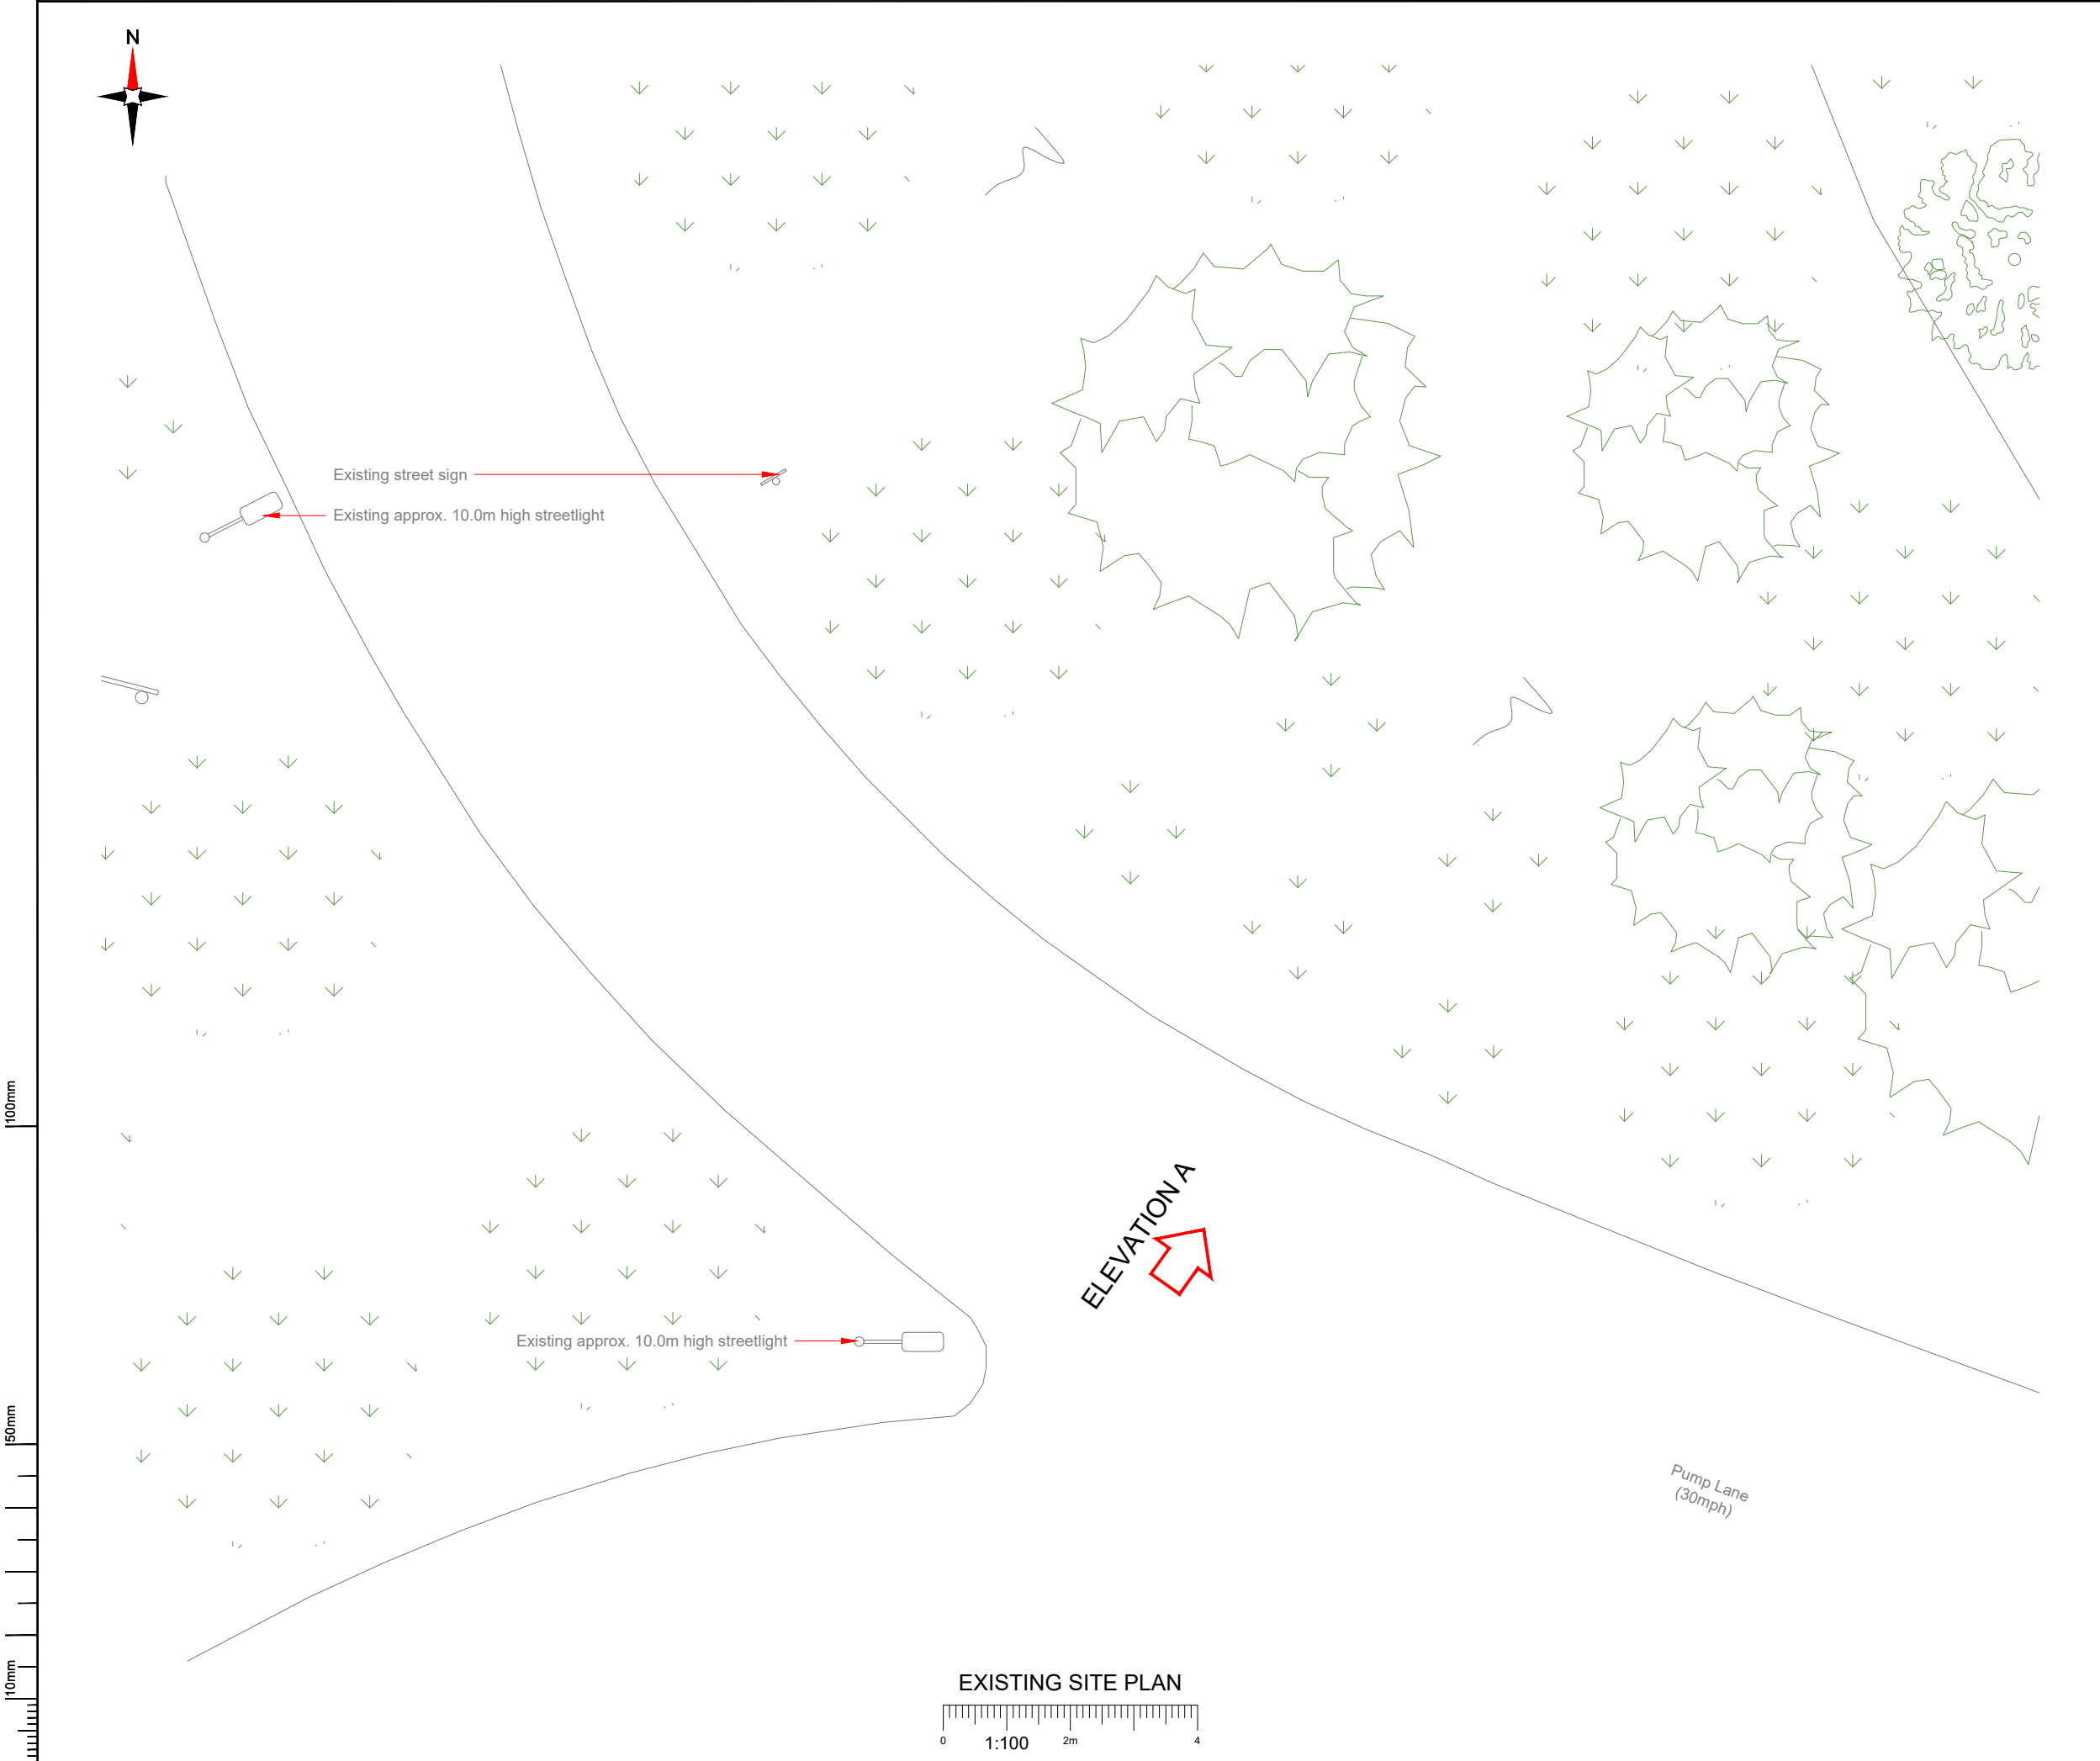


NOTES:

- ALL DIMENSIONS IN MM UNLESS OTHERWISE NOTED.

Master:	MBNL / EE:	Project:	Purpose of Issue:	Issue:
M001	MBNL	3UK DNSW	Planning	A
Date:	20/02/2023	Revision / Upgrade Description:		
Drawn:	CDN	First Issue - Site nomination dated: TBC		
Checked:	DH			
Approved:	SD			

CK Hutchison Networks (UK) Limited
Green Park
450 Longwater Avenue
Reading
RG30 3UR

Design Consultant & Principal Contractor:



WHP Telecoms
Unit 1 Maple Park,
Low Fields Avenue, Leeds
LS12 6HH
Tel: 01133023550
e-mail: info@whptelecoms.com

Site Name:
PUMP LANE STREETWORKS

Site ID:
HGN24072

Address:
PUMP LANE, HAYES,
LONDON BOROUGH OF HILLINGDON,
LONDON,
GREATER LONDON, ENGLAND,
UB3 3NF

Title:
100 EXISTING SITE PLAN

Project:
3UK DNSW

Purpose of Issue:
PLANNING


EE Cell ID:	MBNL Cell ID:	Cell ID:
87591	HGN320	UB1053

Master Drawing No:
HGN24072_M001
Issue:
A

100mm
50mm
10mm



 EXISTING ELEVATION A



- NOTES:
1. ALL DIMENSIONS IN MM UNLESS OTHERWISE NOTED.

Master:	MBNL / EE:	Project:	Purpose of Issue:	Issue:
M001	MBNL	3UK DNSW	Planning	A
Date:	20/02/2023	Revision / Upgrade Description:		
Drawn:	CDN	First Issue - Site nomination dated: TBC		
Checked:	DH			
Approved:	SD			

CK Hutchison
Networks (UK)
Limited

Green Park
450 Longwater Avenue
Reading
RG30 3UR

Design Consultant & Principal Contractor:



WHP Telecoms
Unit 1 Maple Park,
Low Fields Avenue, Leeds
LS12 6HH

Tel: 01133023550
e-mail: info@whptelecoms.com

Site Name:
PUMP LANE STREETWORKS

Site ID:
HGN24072

Address:
PUMP LANE, HAYES,
LONDON BOROUGH OF HILLINGDON,
LONDON,
GREATER LONDON, ENGLAND,
UB3 3NF

Title:
150 EXISTING ELEVATION A

Project:
3UK DNSW

Purpose of Issue:
PLANNING


EE Cell ID: 87591	MBNL Cell ID: HGN320	Cell ID: UB1053
----------------------	-------------------------	--------------------

Master Drawing No: HGN24072_M001	Issue: A
-------------------------------------	-------------



Antenna Aperture ID	Proposed 4G/5G Bearing
A1	340°
A2	340°
C1	220°
C2	220°

NOTES:
1. ALL DIMENSIONS IN MM UNLESS OTHERWISE NOTED.

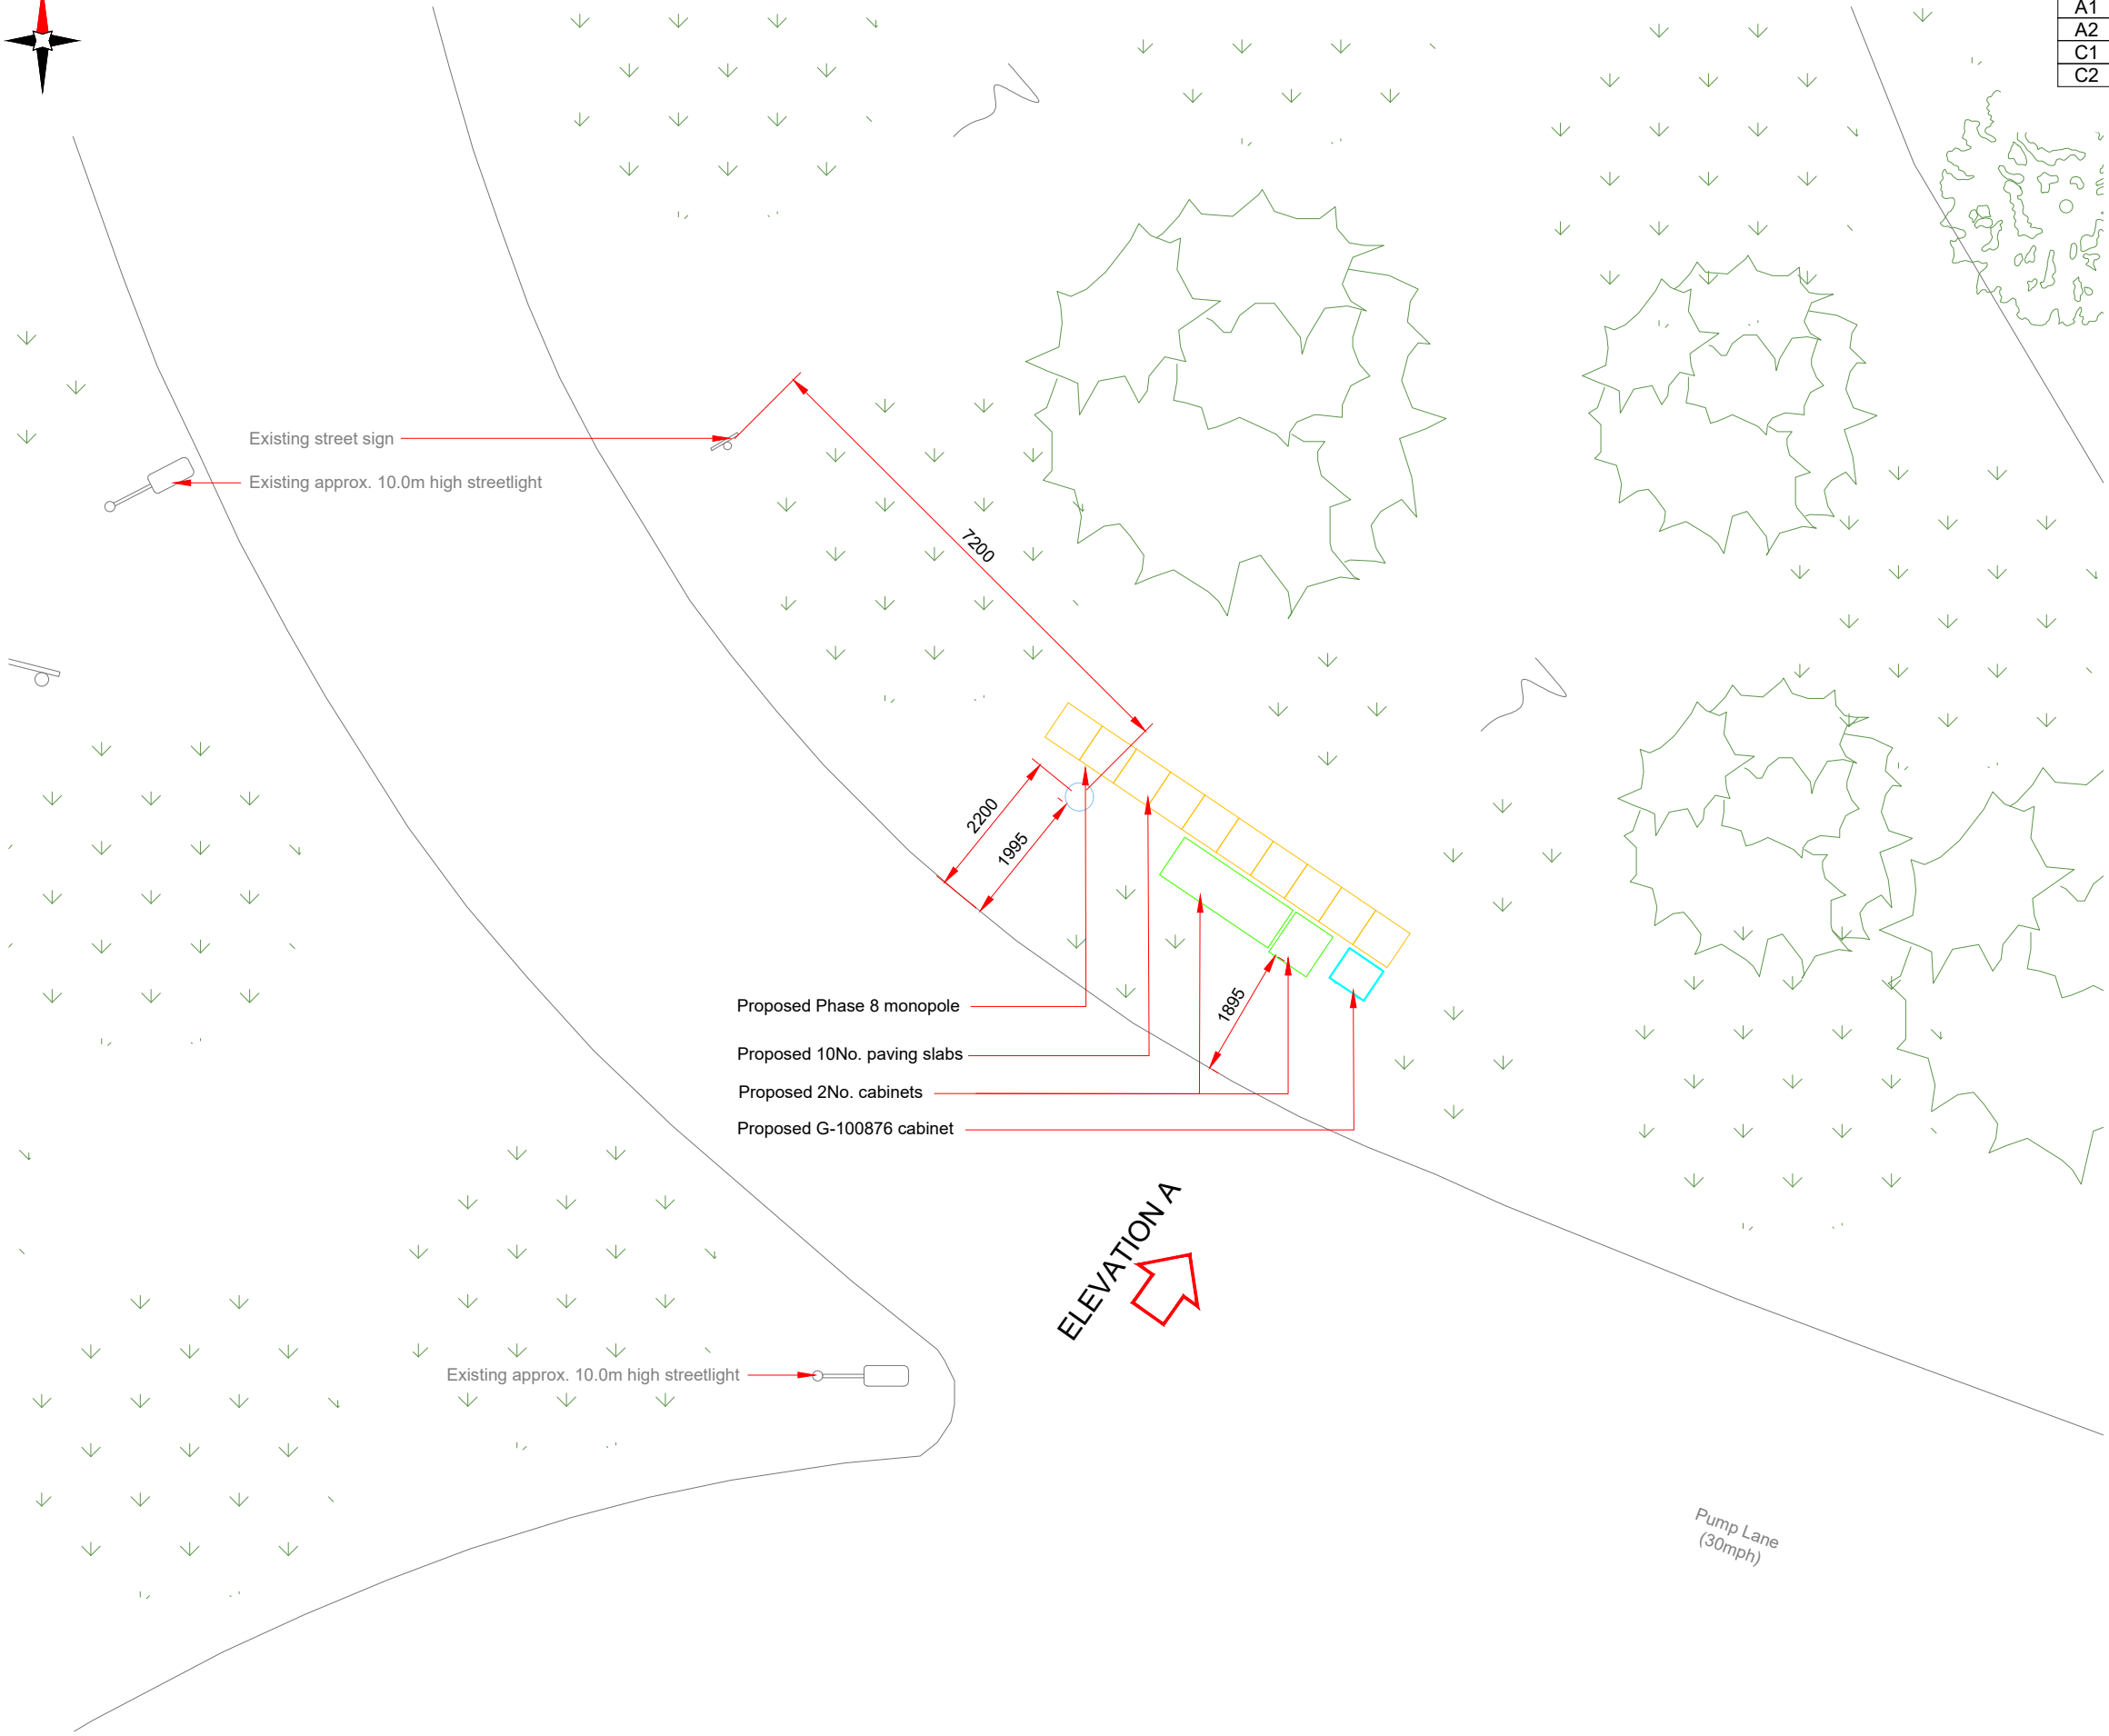


100mm

150mm

10mm

 PROPOSED SITE PLAN



Master:	MBNL / EE:	Project:	Purpose of Issue:	Issue:
M001	MBNL	3UK DNSW	Planning	A
Date:	20/02/2023	Revision / Upgrade Description:		
Drawn:	CDN	First Issue - Site nomination dated: TBC		
Checked:	DH			
Approved:	SD			

CK Hutchison Networks (UK) Limited

Green Park
450 Longwater Avenue
Reading
RG30 3UR

Design Consultant & Principal Contractor:



WHP Telecoms
Unit 1 Maple Park,
Low Fields Avenue, Leeds
LS12 6HH

Tel: 01133023550
e-mail: info@whptelecoms.com

Site Name:
PUMP LANE STREETWORKS

Site ID:
HGN24072

Address:
PUMP LANE, HAYES,
LONDON BOROUGH OF HILLINGDON,
LONDON,
GREATER LONDON, ENGLAND,
UB3 3NF

Title:
210 PROPOSED SITE PLAN

Project:
3UK DNSW

Purpose of Issue:
PLANNING

EE Cell ID: 87591	MBNL Cell ID: HGN320	Cell ID: UB1053
----------------------	-------------------------	--------------------

Master Drawing No: HGN24072_M001	Issue: A
-------------------------------------	-------------

Antenna Aperture ID	Proposed 4G/5G Bearing
A1	340°
A2	340°
C1	220°
C2	220°


NOTES:

1. ALL DIMENSIONS IN MM UNLESS OTHERWISE NOTED.

Master:	MBNL / EE:	Project:	Purpose of Issue:	Issue:
M001	MBNL	3UK DNSW	Planning	A
Date:	20/02/2023	Revision / Upgrade Description:		
Drawn:	CDN	First Issue - Site nomination dated: TBC		
Checked:	DH			
Approved:	SD			

CK Hutchison Networks (UK) Limited

Green Park
450 Longwater Avenue
Reading
RG30 3UR



Design Consultant & Principal Contractor:

WHP Telecoms
Unit 1 Maple Park,
Low Fields Avenue, Leeds
LS12 6HH

Tel: 01133023550
e-mail: info@whptelecoms.com

Site Name: PUMP LANE STREETWORKS

Site ID: HGN24072

Address: PUMP LANE, HAYES,
LONDON BOROUGH OF HILLINGDON,
LONDON,
GREATER LONDON, ENGLAND,
UB3 3NF


Title: 260 PROPOSED ELEVATION

Project: 3UK DNSW


Purpose of Issue: PLANNING

EE Cell ID: 87591	MBNL Cell ID: HGN320	Cell ID: UB1053
----------------------	-------------------------	--------------------

Master Drawing No: HGN24072_M001	Issue: A
-------------------------------------	-------------

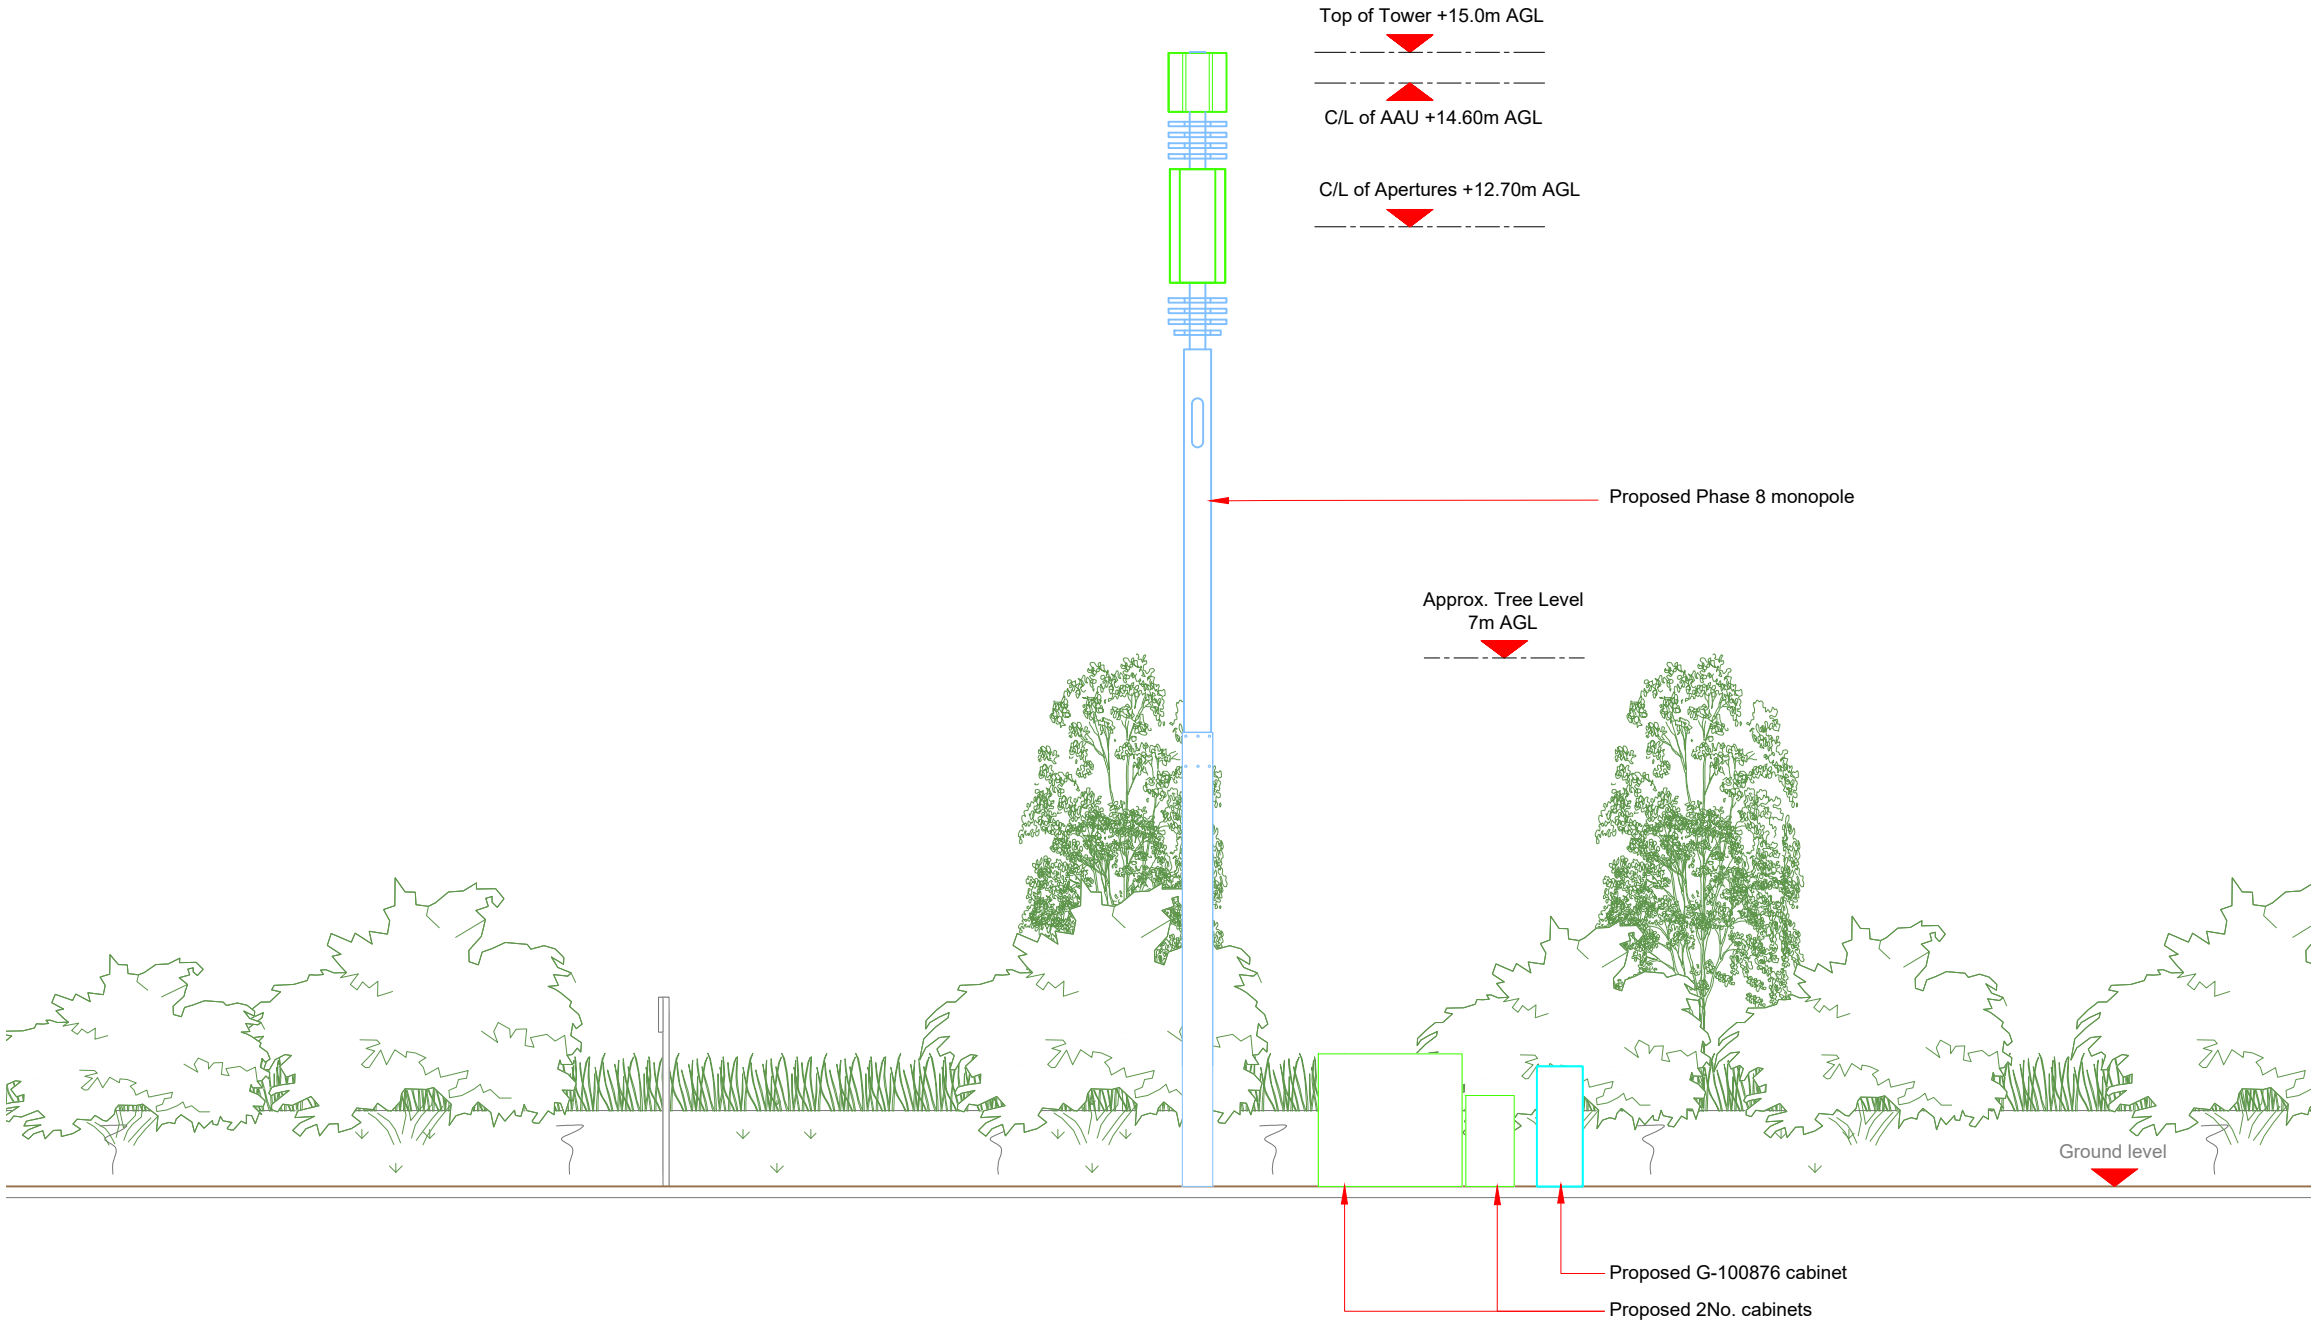

PROPOSED ELEVATION

 

100mm

50mm

10mm