



Metro Engineering, Unit 3,Chartridge Development, Eskdale Rd Uxbridge UB8 2RT



Location plan - 1:2500

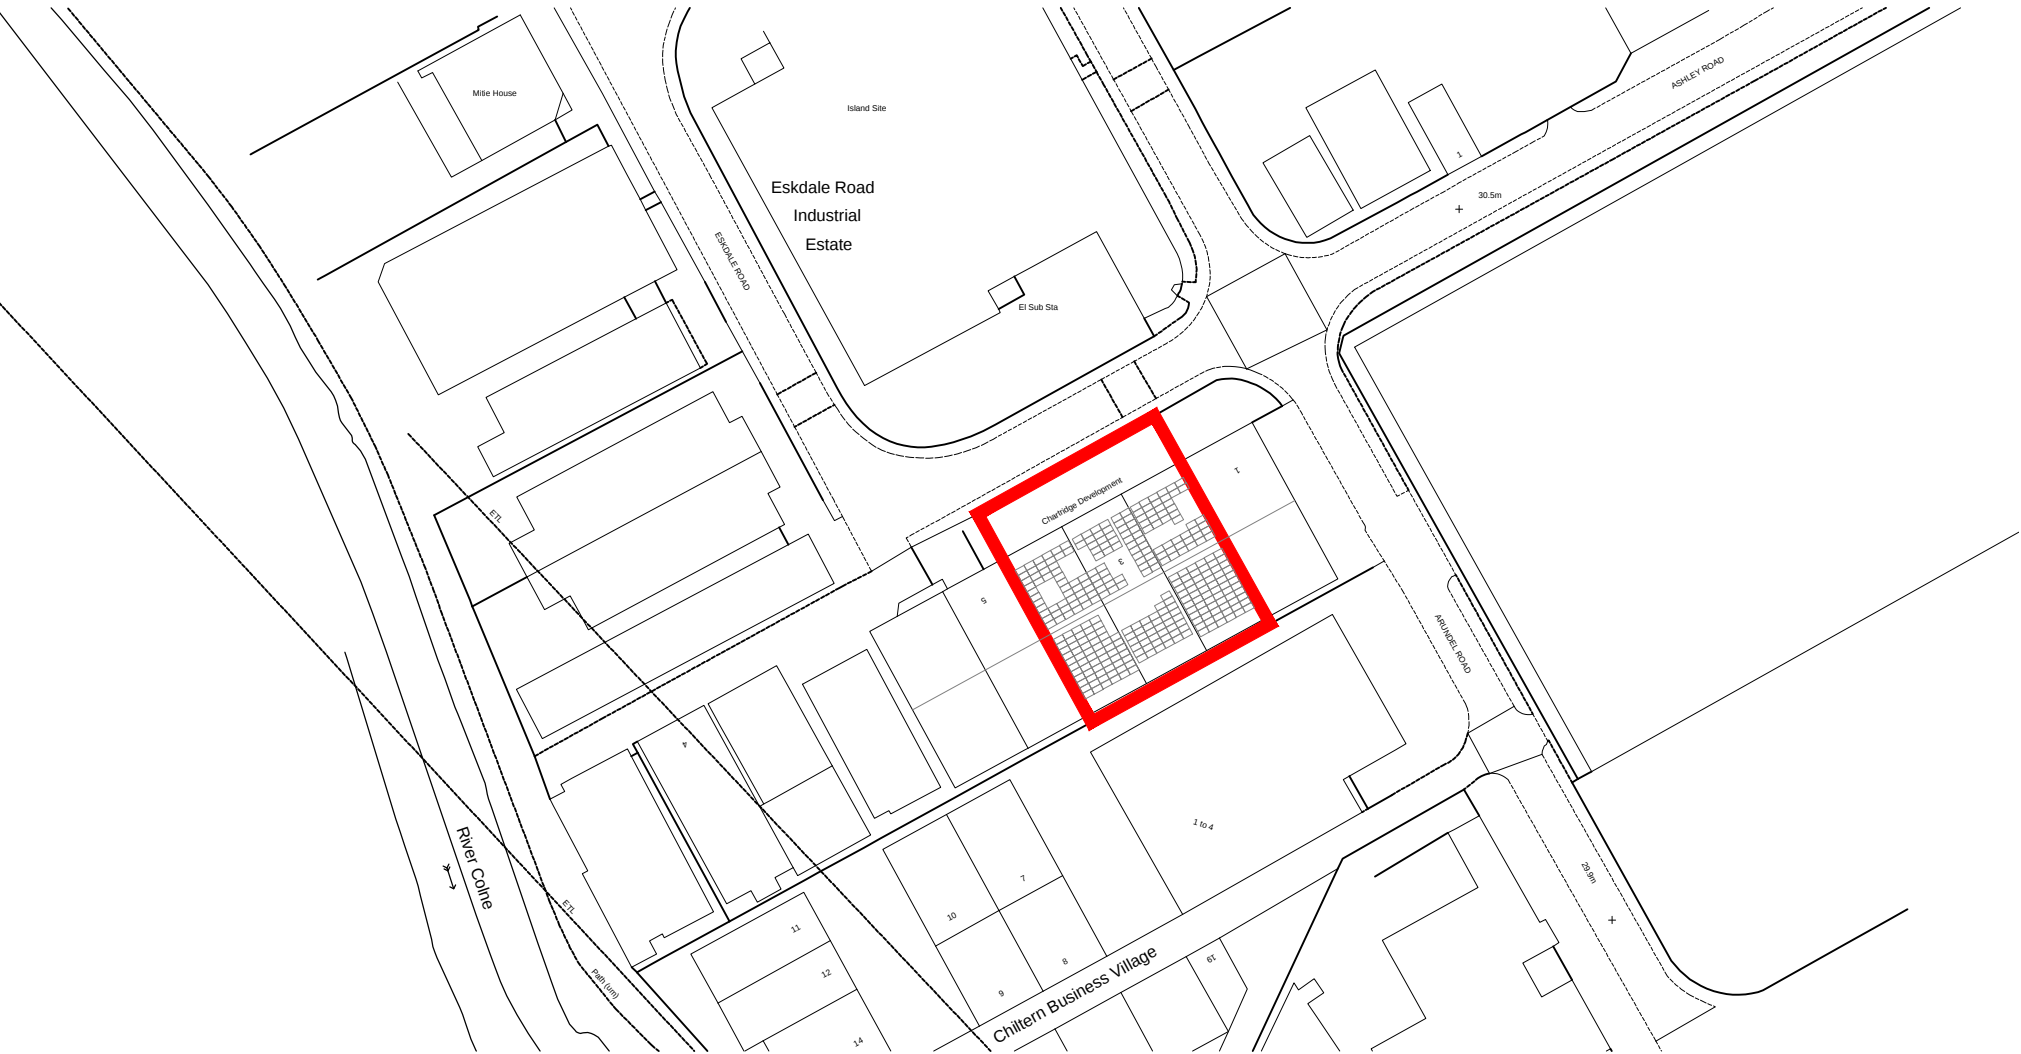

Site plan - 1:500 -

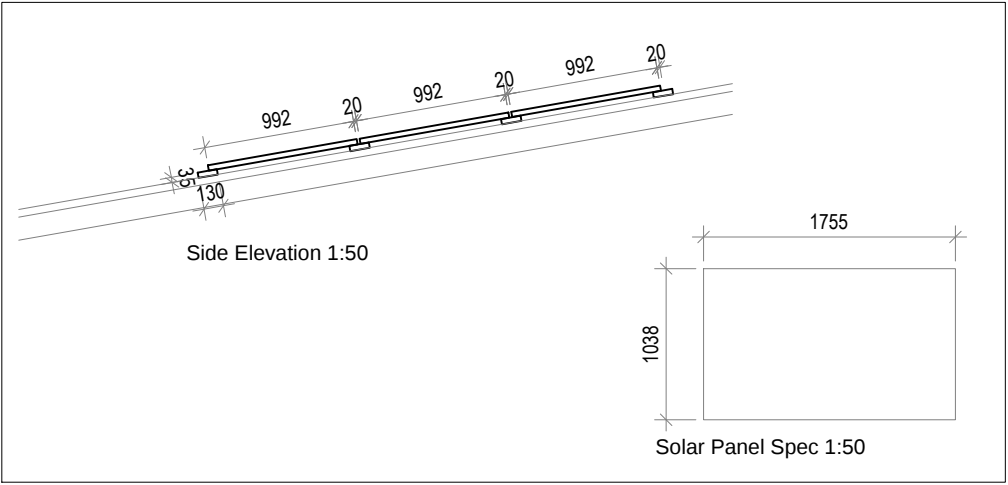

Solar Panel Spec - 1:50

Project Metro Engineering, Unit 3,Chartridge Development, Eskdale Rd Uxbridge UB8 2RT			
Title A4 LOCATION PLAN			
Scale @ A3 1:2500	Date March 2024	Ref Job C0684	Drawn PJM
Drg No LP/C0684			Rev -