




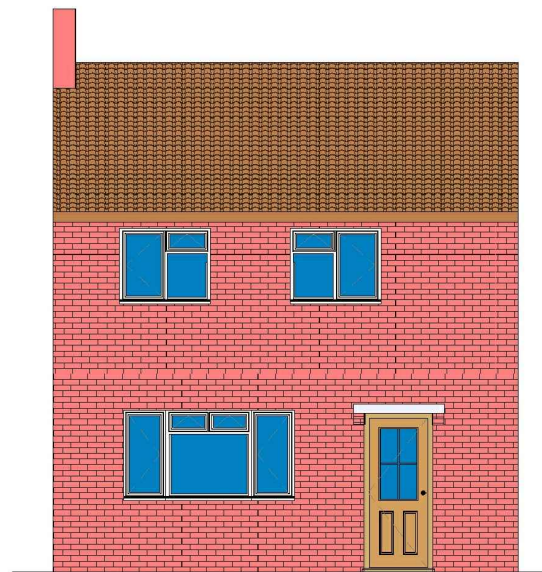


2 Existing Front_Elevation
1 : 100

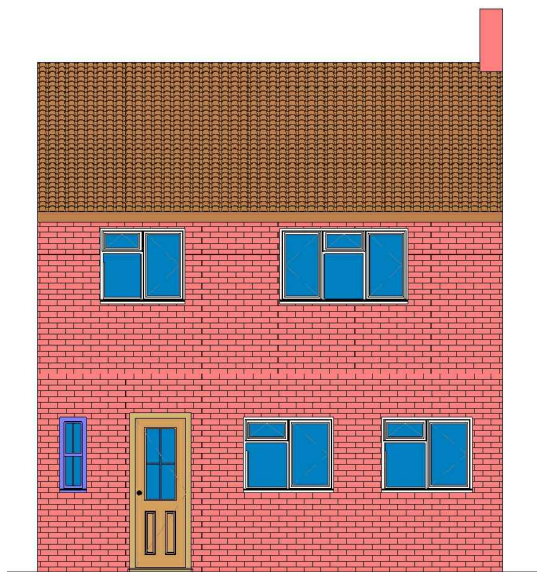



3 Existing Rear_Elevation
1 : 100

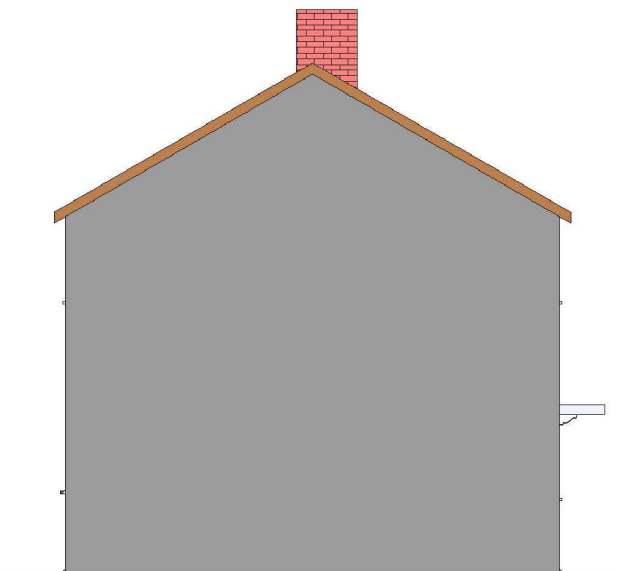

4 Existing Side 01_Elevation
1 : 100

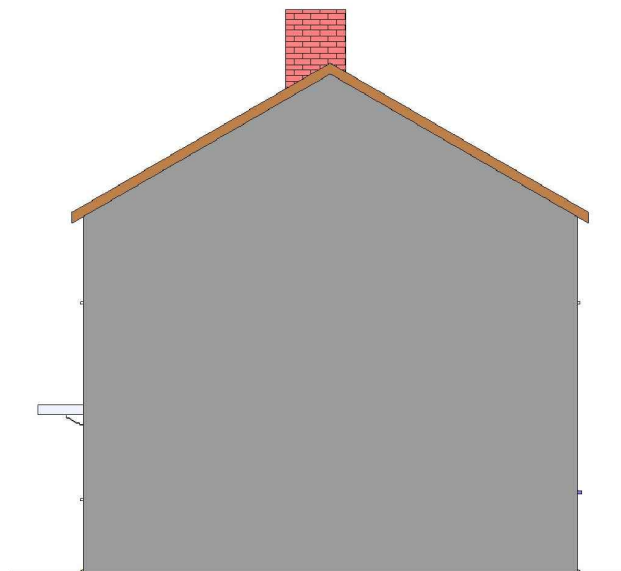

5 Existing Side 02_Elevation
1 : 100

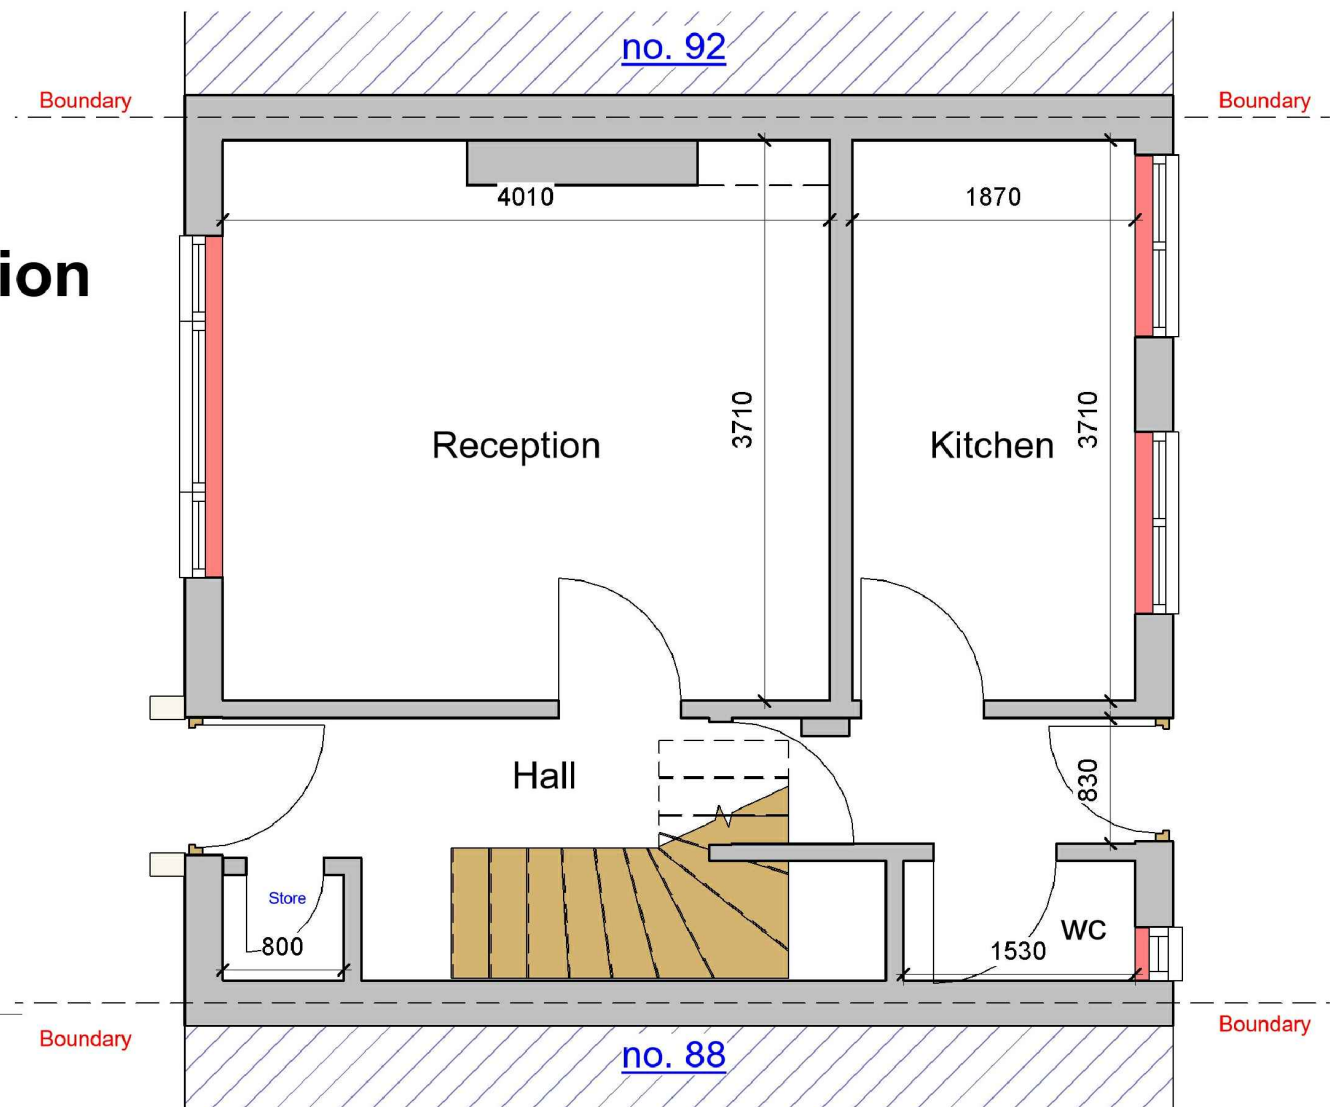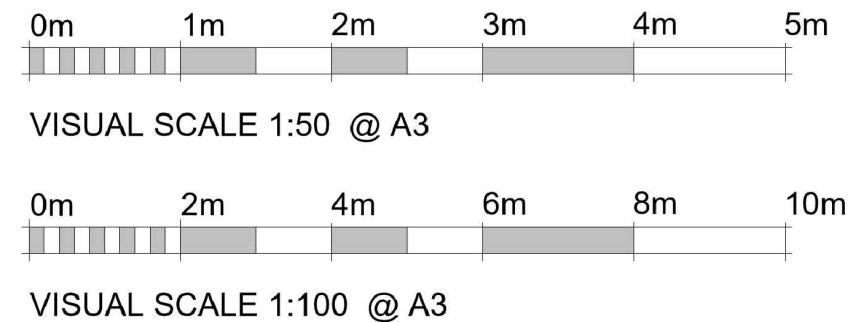

1 Existing Ground Floor
1 : 50

GENERAL NOTES:

- DO NOT SCALE FROM THE DRAWINGS
- ALL DIMENSIONS ARE IN MILLIMETER.
- VERIFY ALL DIMENSIONS AND CONDITIONS BEFORE BUILDING OR STARTING CONSTRUCTION.
- NOTIFY THE DESIGNER IMMEDIATELY OF ANY DISCREPANCY OR VARIATION.
- ALL WORK TO COMPLY WITH CURRENT BUILDING REGULATIONS AND CODES OF PRACTICE.



NISARG@HOTMAIL.COM

+44 - 7951491310

PROJECT

90 Whitethorn Ave, West Drayton UB7 8LA

SHEET

Existing Ground Floor Plan & Elevations

CLIENT

Mr Fasil


Date	Project number	Scale (@ A3)
Issue Date	Project Number	
Drawn by	DRWAING NUMBER	REV
Author		
Checked by	A101- 4.0m	
Checker		

- FD 30

Fire check doors 30 min fire resistance with smoke seal and self closing
- HD


Heat Detector comply with BS 5466 2:2016
- Smoke alarm/detector to comply with BS EN14604
- EL

 Emergency lights To be Installed in Accordance with BS5266: 2016



VISUAL SCALE 1:50 @ A3

- Assembly Point
- Foam 6 litre foam spray
- Call Point

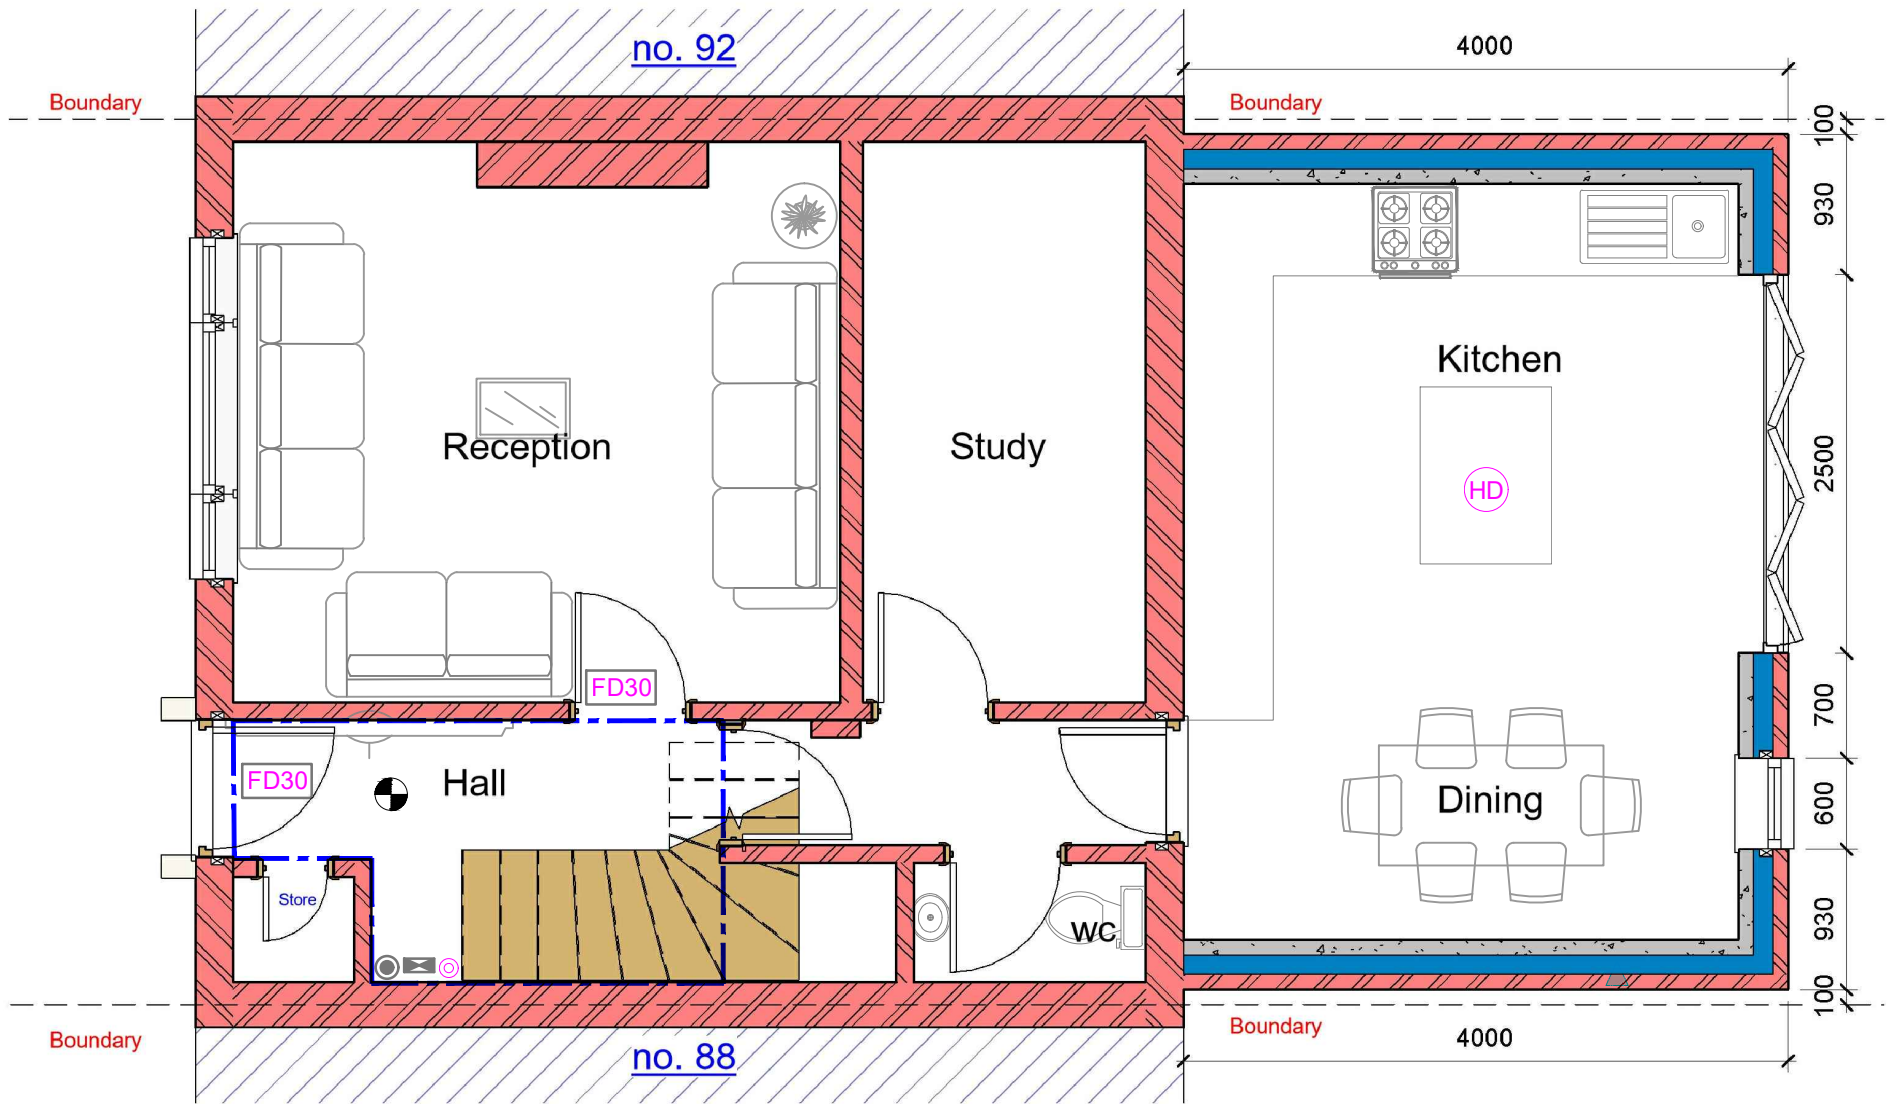

- Fire Alarm System comly with BS 5839:Part 1:2017
- FIRE EXIT

Fire Exit Sign Comply with BS 5499
- CM

Carbon Monoxide Detector
- Extract Vent

1

Proposed Ground Floor

1 : 50

GENERAL NOTES:

1. DO NOT SCALE FROM THE DRAWINGS
2. ALL DIMENTIONS ARE IN MILLIMETER.
3. VERIFY ALL DIMENSIONS AND CONDITIONS BEFORE BUILDING OR STARTING CONSTRUCTION.
4. NOTIFY THE DESIGNER IMMEDIATELY OF ANY DISCREPANCY OR VARIATION.
5. ALL WORK TO COMPLY WITH CURRENT BUILDING REGULATIONS AND CODES OF PRACTICE.



Art @ Rooshika

NISARG@HOTMAIL.COM

+44 - 7951491310

PROJECT

90 Whitethorn Ave, West Drayton UB7 8LA


SHEET

Proposed Ground Floor Plan


CLIENT

Mr Fasil



Date	Project number	Scale (@ A3)
Issue Date	Project Number	
Drawn by	DRWAING NUMBER	REV
Author		
Checked by	A103- 4.0m	
Checker		

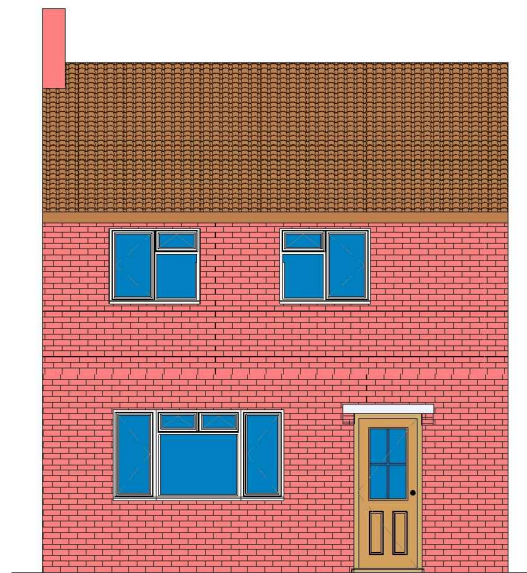

1 **Proposed Front_Elevation**
1 : 100

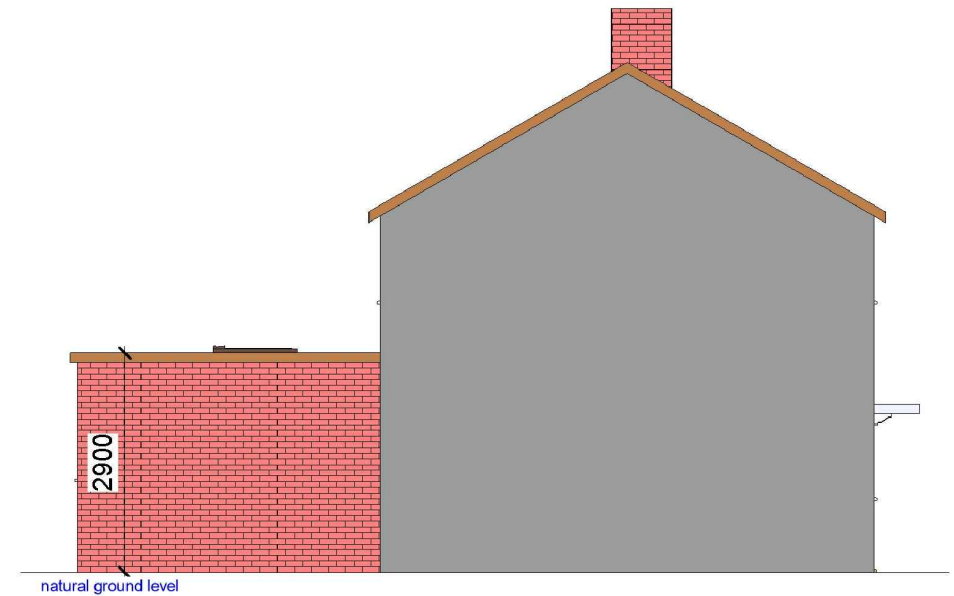

2 **Proposed Side 01_Elevation**
1 : 100

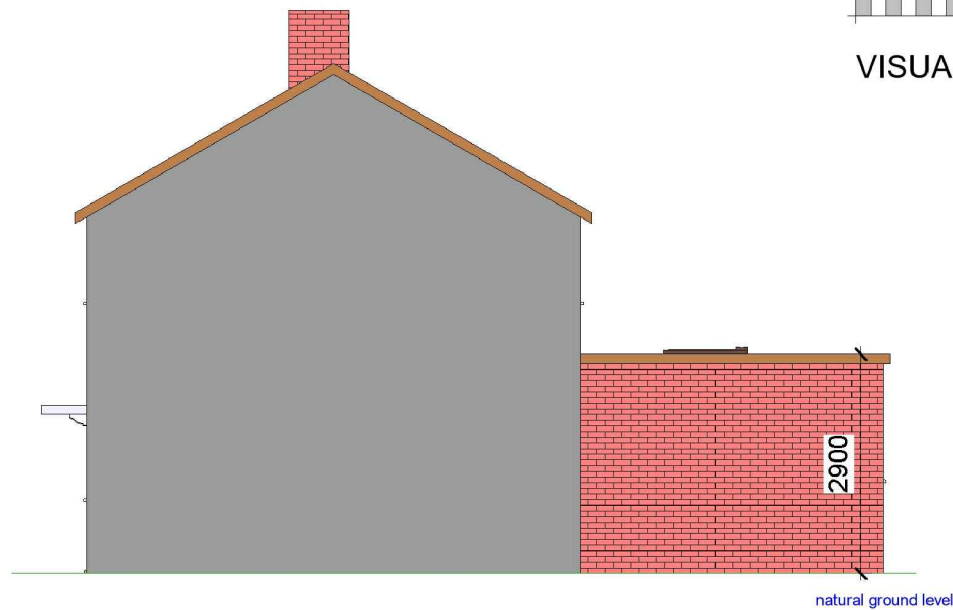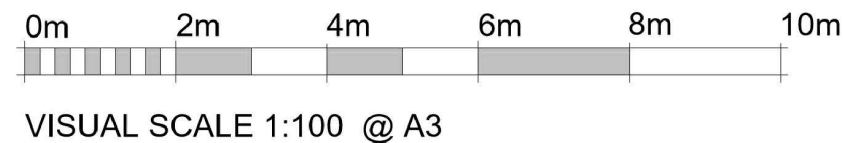

4 **Proposed Side 02_Elevation**
1 : 100



3 **Proposed Rear_Elevation**
1 : 100

GENERAL NOTES:

- DO NOT SCALE FROM THE DRAWINGS
- ALL DIMENSIONS ARE IN MILLIMETER.
- VERIFY ALL DIMENSIONS AND CONDITIONS BEFORE BUILDING OR STARTING CONSTRUCTION.
- NOTIFY THE DESIGNER IMMEDIATELY OF ANY DISCREPANCY OR VARIATION.
- ALL WORK TO COMPLY WITH CURRENT BUILDING REGULATIONS AND CODES OF PRACTICE.



Art @ Rooshika

NISARG@HOTMAIL.COM

+44 - 7951491310

PROJECT

90 Whitethorn Ave, West Drayton UB7 8LA

SHEET

Proposed Elevations

CLIENT

Mr Fasil

Date

Issue Date

Drawn by

Author

Checked by

Checker

Project number


Project Number

DRWAING NUMBER

A104- 4.0m


Scale (@ A3)

REV

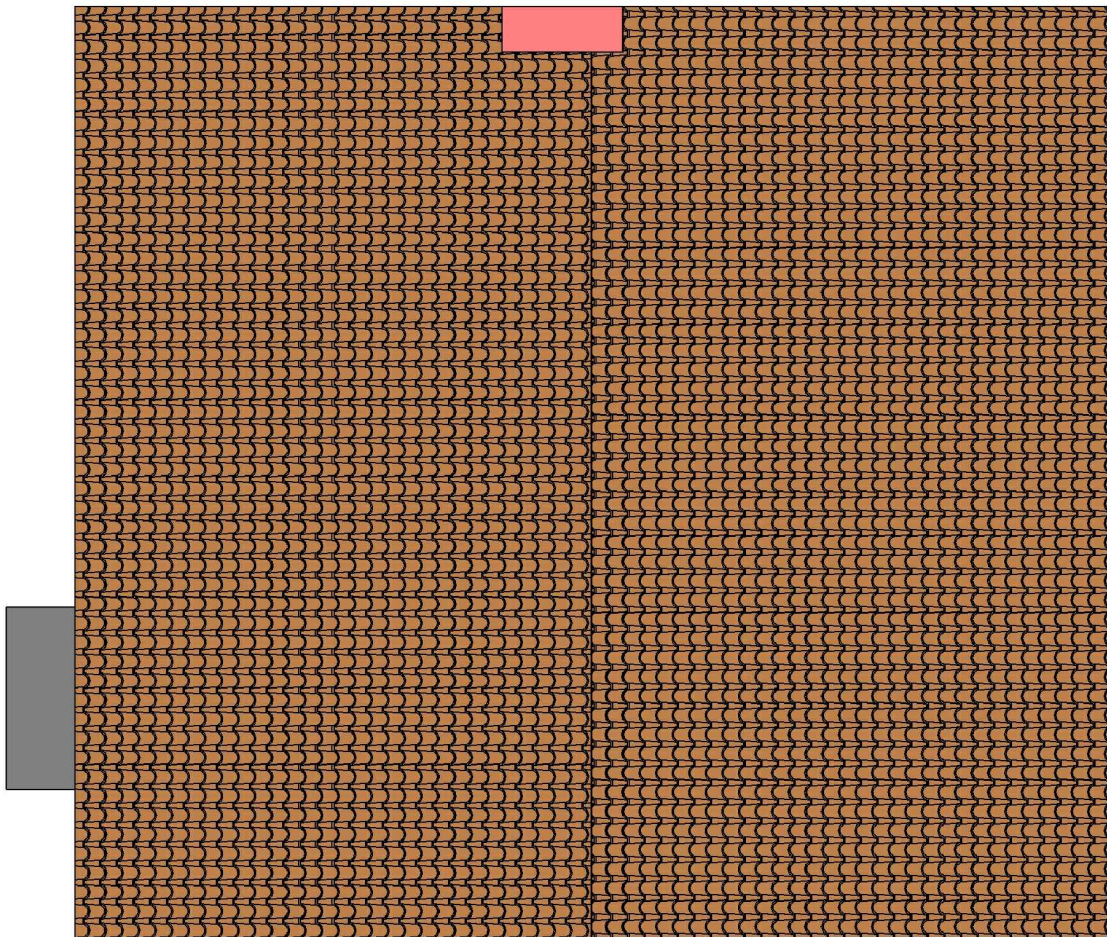

VISUAL SCALE 1:50 @ A3

1 Existing Roof
1 : 50

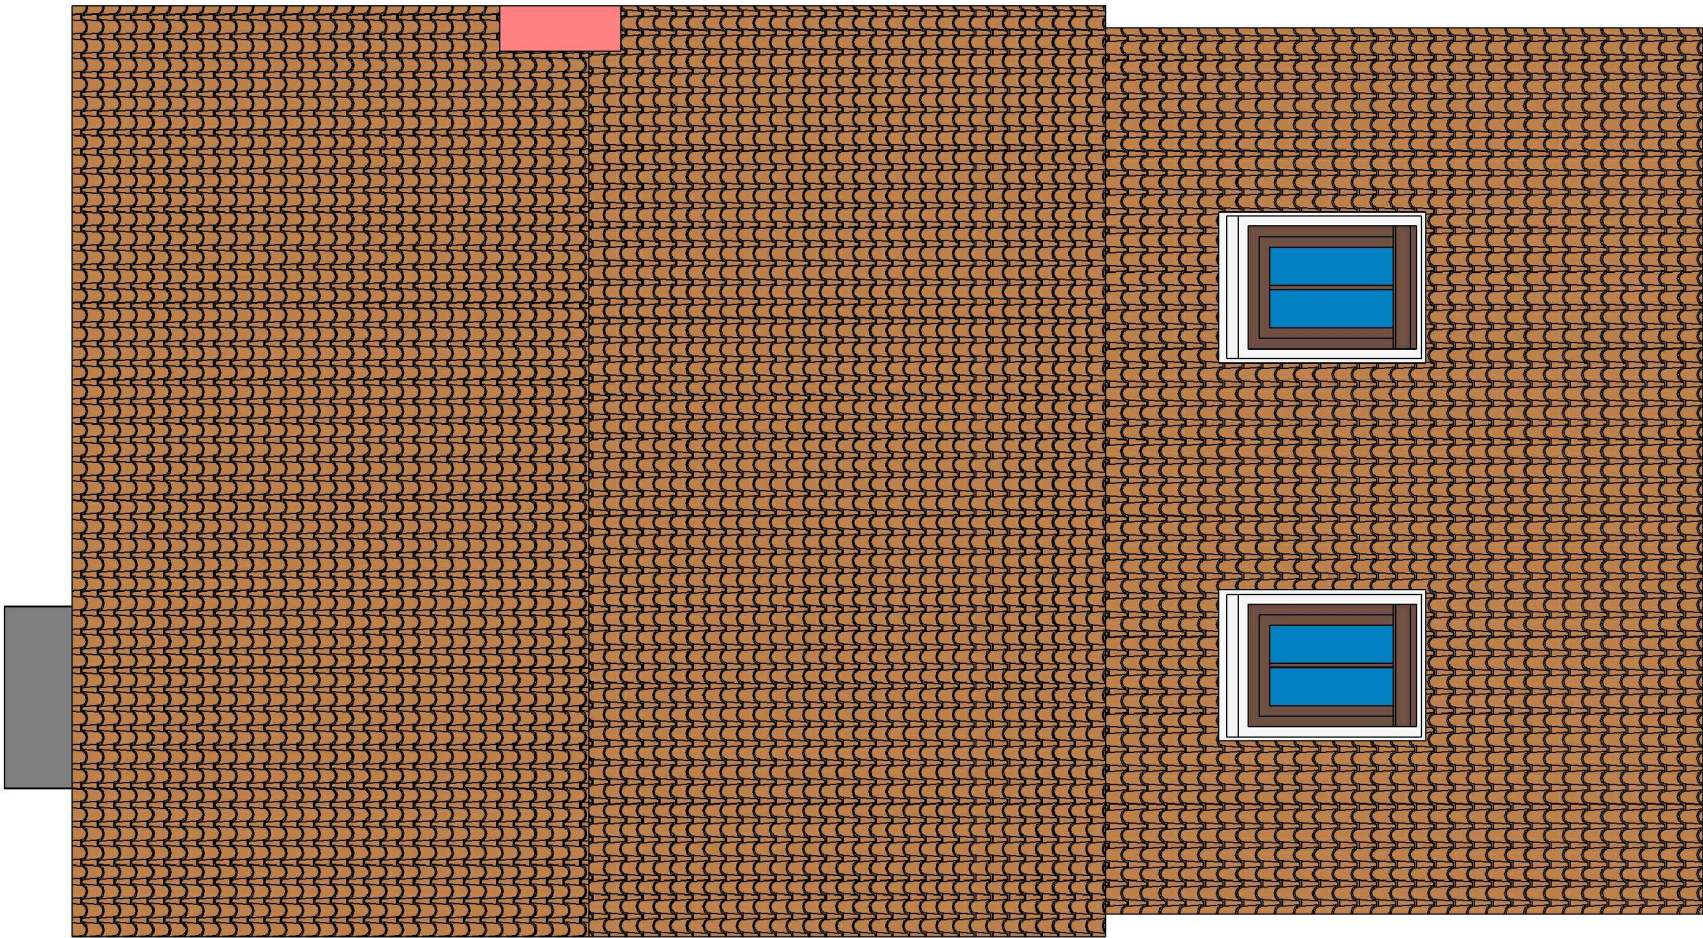

2 Proposed Roof
1 : 50

GENERAL NOTES:

- 1. DO NOT SCALE FROM THE DRAWINGS
- 2. ALL DIMENTIONS ARE IN MILLIMETER.
- 3. VERIFY ALL DIMENSIONS AND CONDITIONS BEFORE BUILDING OR STARTING CONSTRUCTION.
- 4. NOTIFY THE DESIGNER IMMEDIATELY OF ANY DISCREPANCY OR VARIATION.
- 5. ALL WORK TO COMPLY WITH CURRENT BUILDING REGULATIONS AND CODES OF PRACTICE.



Art @ Rooshika

NISARG@HOTMAIL.COM

+44 - 7951491310

PROJECT

90 Whitethorn Ave, West Drayton UB7 8LA

SHEET

Existing & Proposed Roof Plan

CLIENT

Mr Fasil

Date

Issue Date

Drawn by

Author

Checked by
Checker

Project number


Project Number

DRWAING NUMBER


A105- 4.0m

Scale (@ A3)

REV

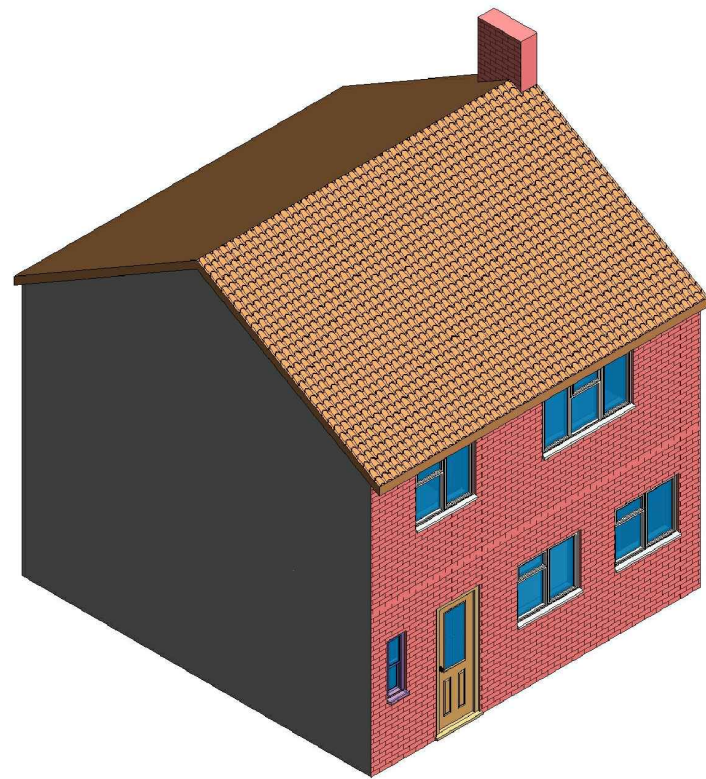

1 3D View 01 Existing

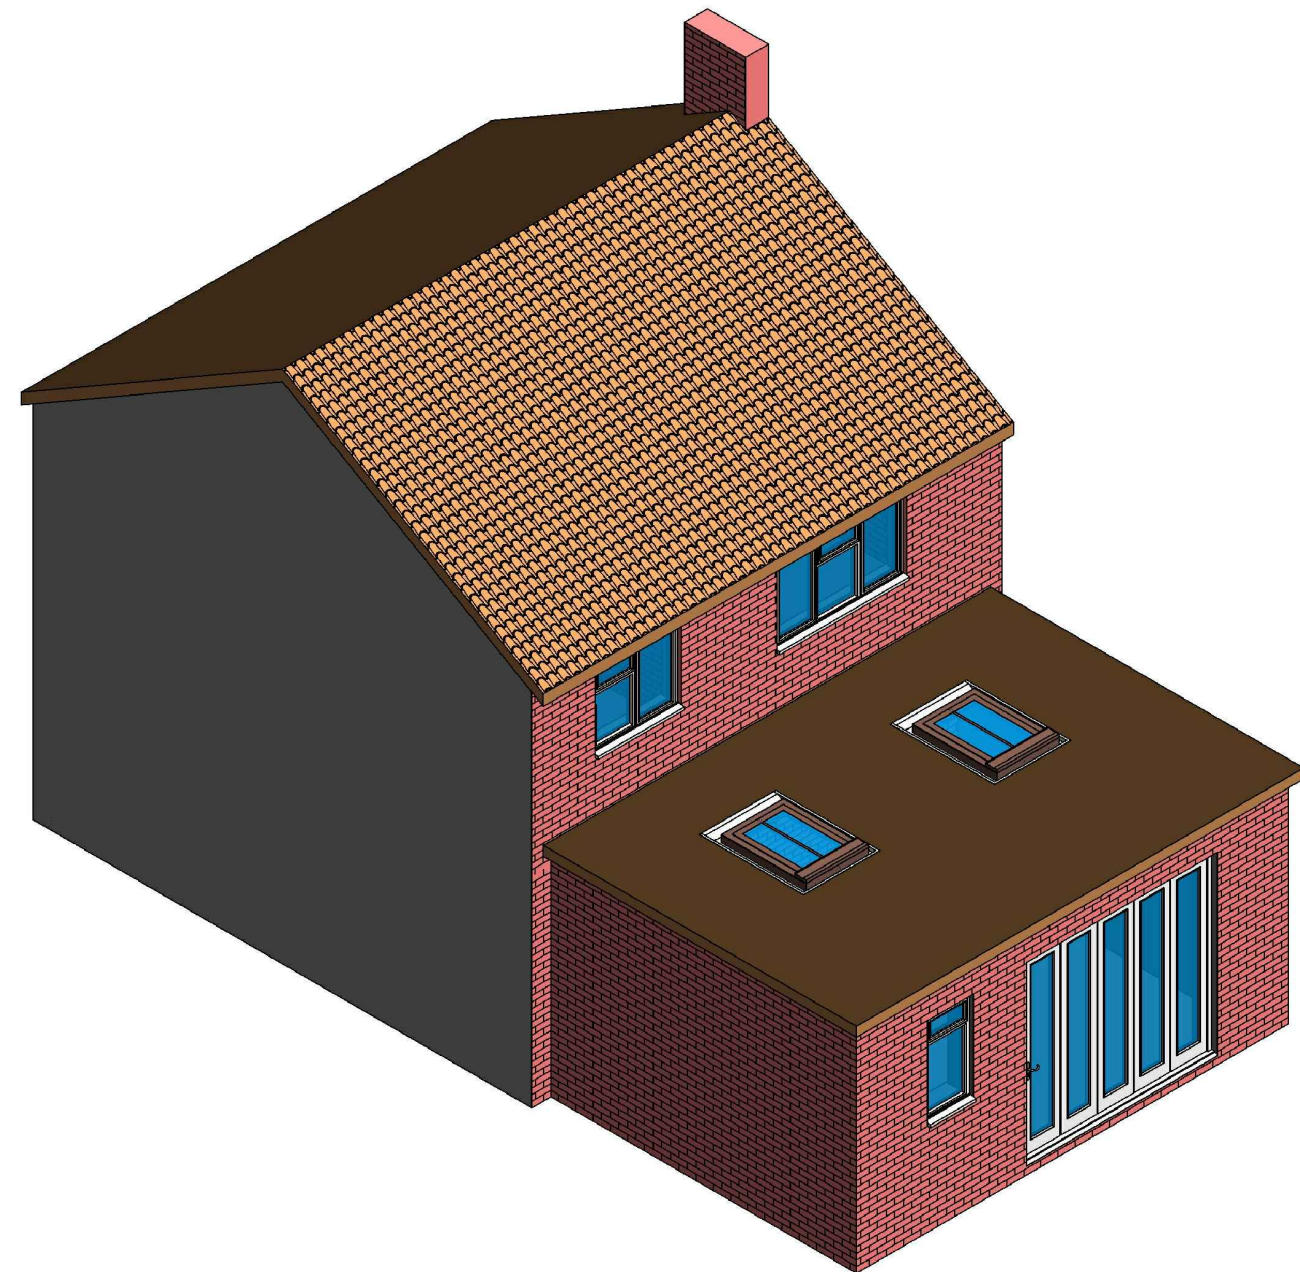

2 3D View 01 Proposed

GENERAL NOTES:

- DO NOT SCALE FROM THE DRAWINGS
- ALL DIMENTIONS ARE IN MILLIMETER.
- VERIFY ALL DIMENSIONS AND CONDITIONS BEFORE BUILDING OR STARTING CONSTRUCTION.
- NOTIFY THE DESIGNER IMMEDIATELY OF ANY DISCREPANCY OR VARIATION.
- ALL WORK TO COMPLY WITH CURRENT BUILDING REGULATIONS AND CODES OF PRACTICE.



Art @ Rooshika
 NISARG@HOTMAIL.COM
 +44 - 7951491310

PROJECT		CLIENT		
90 Whitethorn Ave, West Drayton UB7 8LA		Mr Fasil		
SHEET	3D Views	Date	Project number	Scale (@ A3)
		Issue Date	Project Number	
		Drawn by	DRWAING NUMBER	REV
		Author	A106- 4.0m	
		Checked by		
		Checker		