


LINGFIELD CLOSE


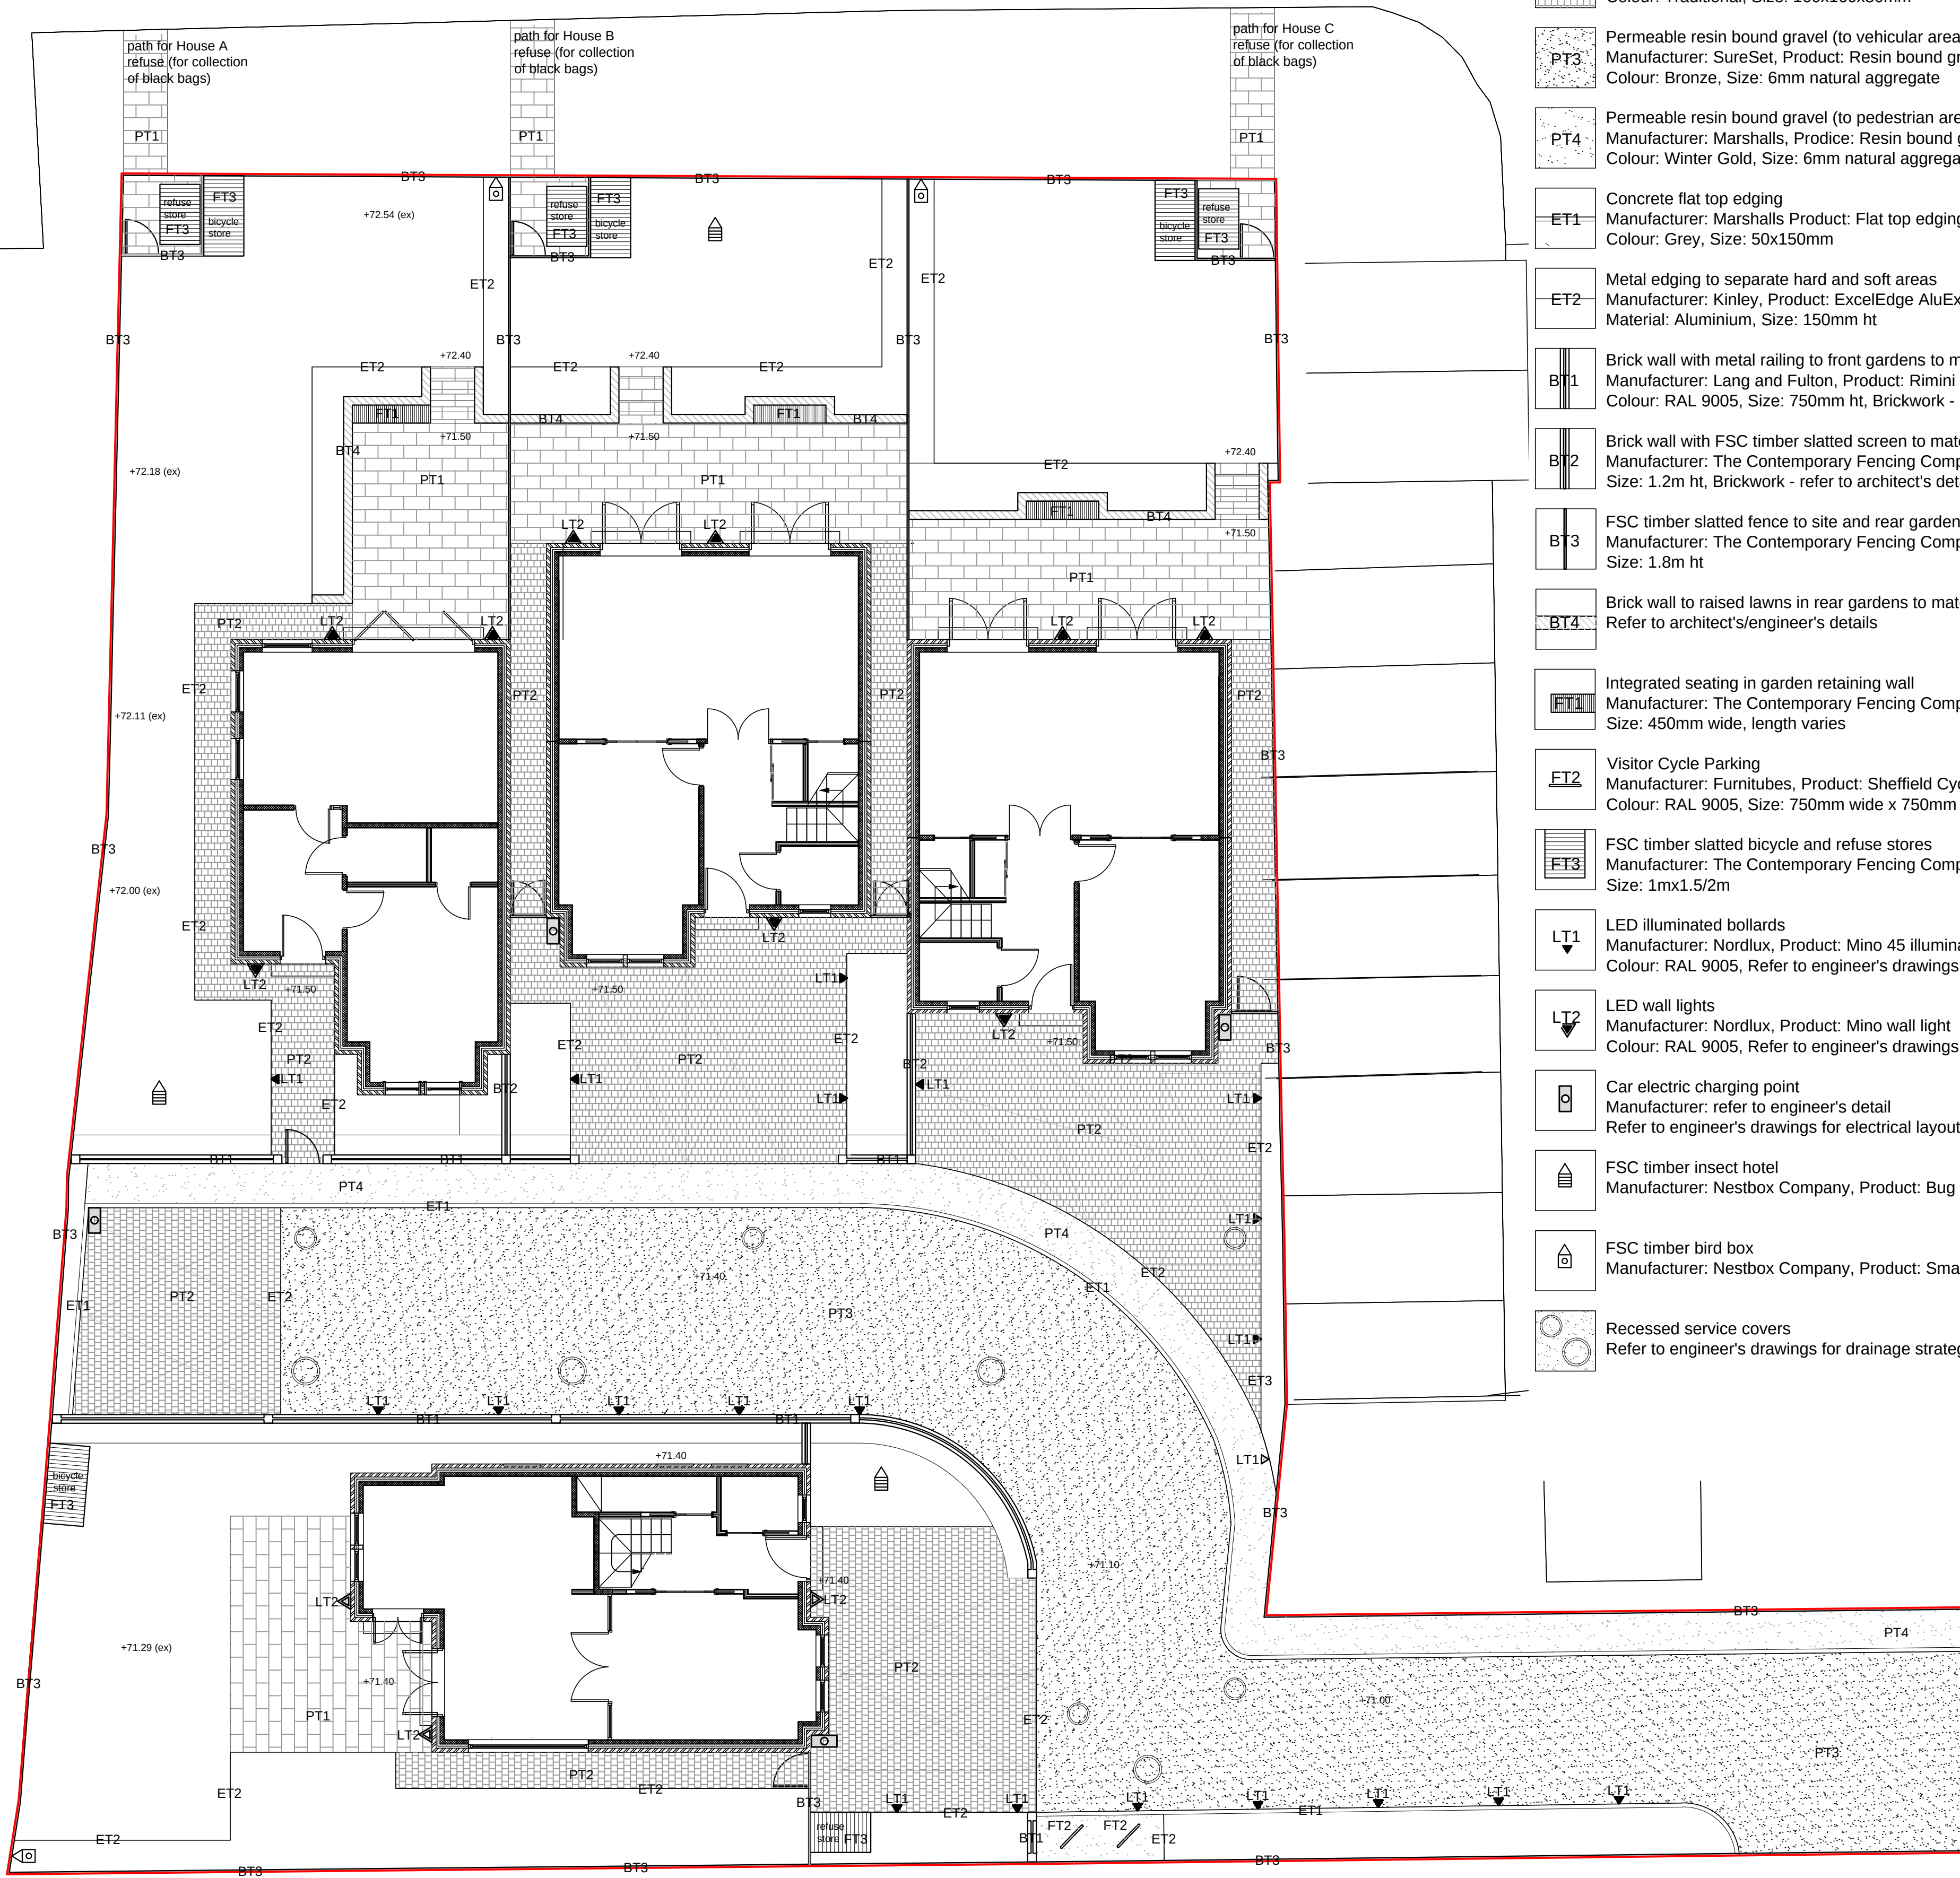


HARD MATERIALS SCHEDULE

- PT1** Permeable concrete aggregate flag paving
Manufacturer: Marshalls, Product: Conservation X Priora (or similar approved)
Colour: Silver Grey, Size: 600x400x65mm, 400x400x65mm and 400x200x65mm
- PT2** Permeable block paving
Manufacturer: Marshalls, Product: Tegula Priora (or similar approved)
Colour: Traditional, Size: 160x160x80mm
- PT3** Permeable resin bound gravel (to vehicular areas)
Manufacturer: SureSet, Product: Resin bound gravel paving (or similar approved)
Colour: Bronze, Size: 6mm natural aggregate
- PT4** Permeable resin bound gravel (to pedestrian areas)
Manufacturer: Marshalls, Product: Resin bound gravel paving (or similar approved)
Colour: Winter Gold, Size: 6mm natural aggregate
- ET1** Concrete flat top edging
Manufacturer: Marshalls Product: Flat top edging (or similar approved)
Colour: Grey, Size: 50x150mm
- ET2** Metal edging to separate hard and soft areas
Manufacturer: Kinley, Product: ExcelEdge AluExcel (or similar approved)
Material: Aluminium, Size: 150mm ht
- BT1** Brick wall with metal railing to front gardens to match architectural brickwork, 1.2m ht overall
Manufacturer: Lang and Fulton, Product: Rimini railing and match gates (or similar approved)
Colour: RAL 9005, Size: 750mm ht, Brickwork - refer to architect's detail
- BT2** Brick wall with FSC timber slatted screen to match architectural brickwork, 1.5m overall ht
Manufacturer: The Contemporary Fencing Company, Product: Cequence fencing (or similar approved)
Size: 1.2m ht, Brickwork - refer to architect's detail
- BT3** FSC timber slatted fence to site and rear garden boundaries
Manufacturer: The Contemporary Fencing Company, Product: Cequence fencing (or similar approved)
Size: 1.8m ht
- BT4** Brick wall to raised lawns in rear gardens to match architectural brickwork
Refer to architect's/engineer's details
- FT1** Integrated seating in garden retaining wall
Manufacturer: The Contemporary Fencing Company, Product: bespoke (or similar approved)
Size: 450mm wide, length varies
- ET2** Visitor Cycle Parking
Manufacturer: Furnitubes, Product: Sheffield Cycle Stand (or similar approved)
Colour: RAL 9005, Size: 750mm wide x 750mm high
- FT3** FSC timber slatted bicycle and refuse stores
Manufacturer: The Contemporary Fencing Company, Product: Garden Store (or similar approved)
Size: 1mx1.5/2m
- LT1** LED illuminated bollards
Manufacturer: Nordlux, Product: Mino 45 illuminated bollard (or similar approved)
Colour: RAL 9005, Refer to engineer's drawings for electrical layout
- LT2** LED wall lights
Manufacturer: Nordlux, Product: Mino wall light
Colour: RAL 9005, Refer to engineer's drawings for electrical layout
- LT3** Car electric charging point
Manufacturer: refer to engineer's detail
Refer to engineer's drawings for electrical layout
- LT4** FSC timber insect hotel
Manufacturer: Nestbox Company, Product: Bug hotel (or similar approved)
- LT5** FSC timber bird box
Manufacturer: Nestbox Company, Product: Small bird nest box (or similar approved)
- LT6** Recessed service covers
Refer to engineer's drawings for drainage strategy, design and requirements

NOTES
Do not scale from this drawing. Only figured dimensions are to be taken from this drawing.

0m 5m

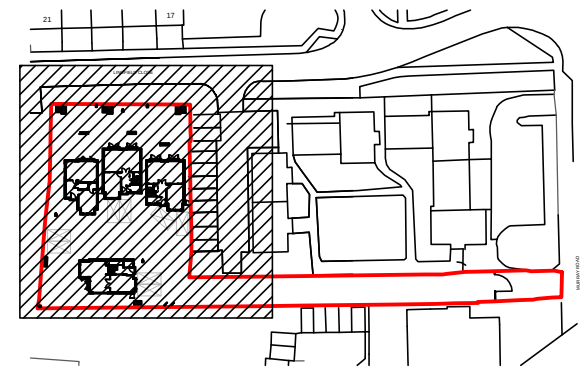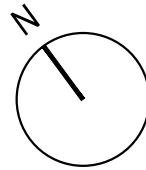

REV	AMENDMENT / ISSUE	DATE
A	Edging amended	24.03.21

HENSHALL
GREEN

LANDSCAPE ARCHITECTS

info@henshallgreen.com
www.henshallgreen.com

Luxgrove
Capital Partners

CLIENT

48 Murray Road
Harrow HA6 2YL

PROJECT

Hard Materials Plan
1 of 2

DRAWING			
1:100@A1		Planning	
SCALE		STATUS	
March 2021		PH	
DATE		ISSUED BY	
090	GF HW 201	A	
PROJECT No. DRAWING No.		REVISION	